


LEGEND	
SL.NO.	DESCRIPTION
01.	Column (300 X 300)
02.	Brick Wall
03.	Windows
04.	Partitions
05.	Doors
06.	Water Supply pipe
07.	Storm water Pipe
08.	Manhole 600 X 600 mm

- NOTES :
1. All Dimension are in Millimetre Otherwise Stated.
 2. All Levels are in metre and are with assume RL 100.0

FOR TENDER PURPOSE ONLY

TITLE : UNIT PLAN

DRAWN BY: VIA INNOTECH	CHECKED BY: P. K. GROVER
DATE: DEC 2008	
SCALE: 500 0 500 1500 2500 MM	
DWG NO: RANGH/UNIT PLAN/01	REV: 0

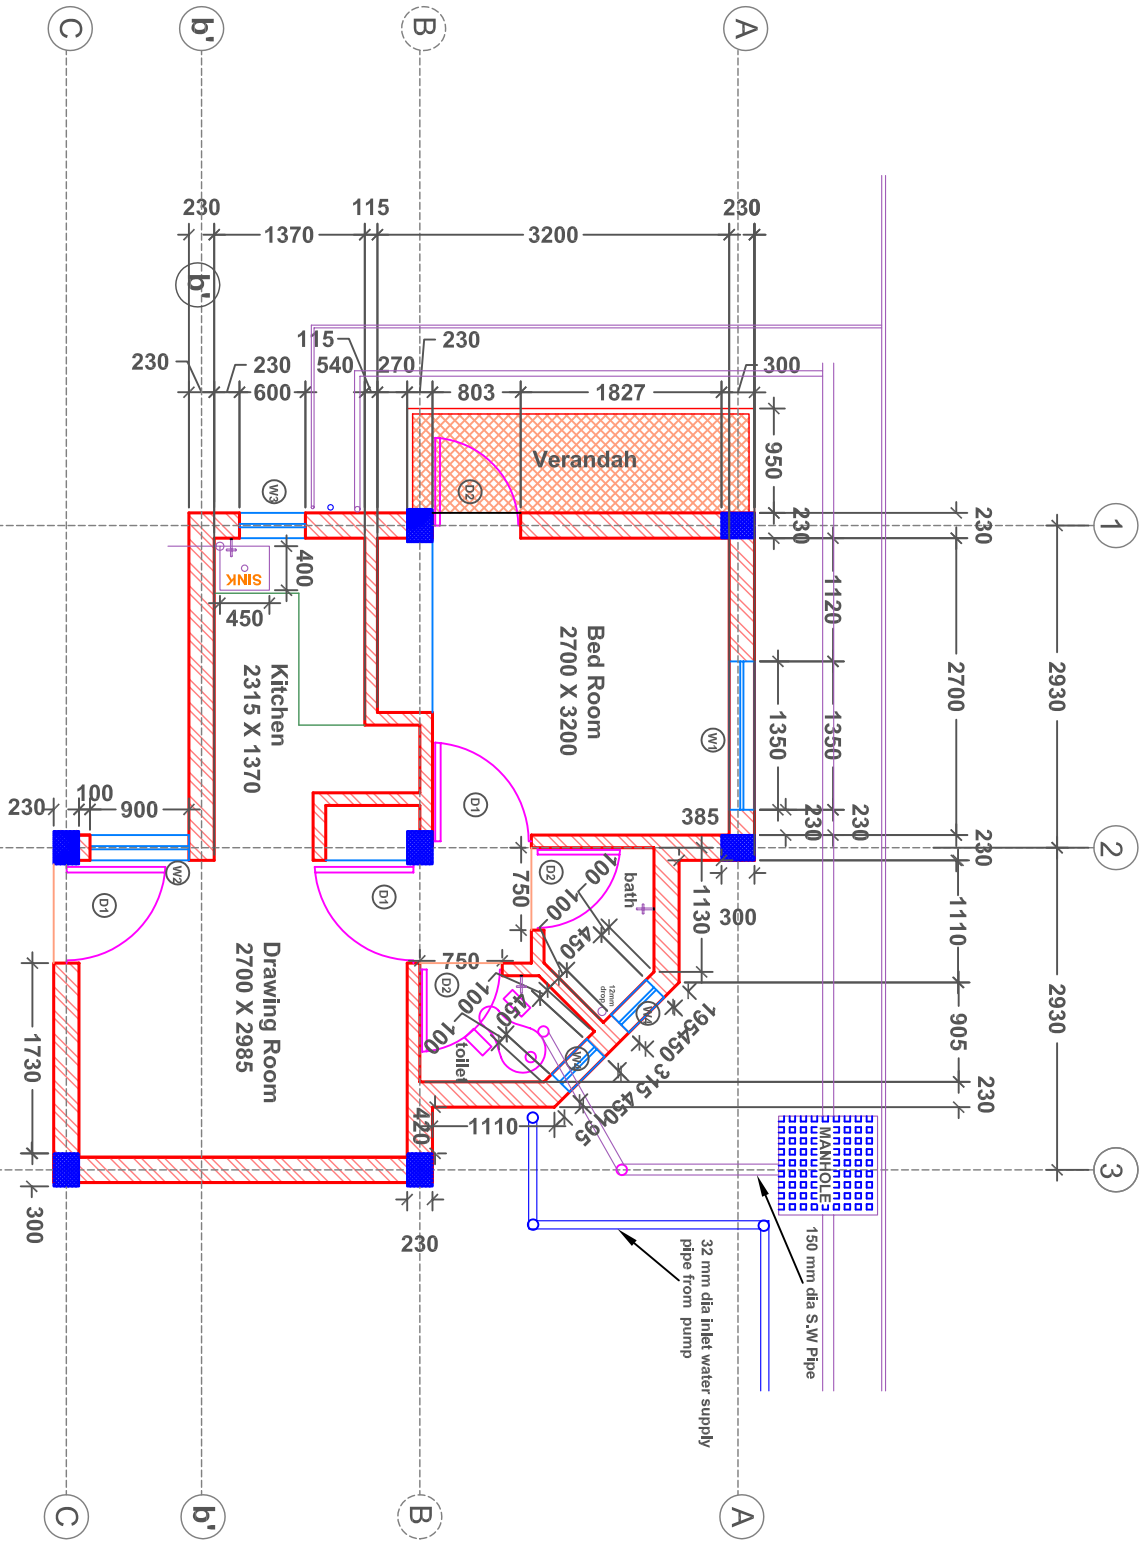


AREA STATEMENT

CARPET AREA/D.U.: 25.10SQ.M
PLINTH AREA/D.U.: 31.00 SQ.M

BSUP

UNIT PLAN SERVICE

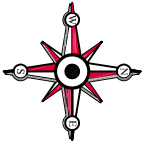

LEGEND	
SL.NO.	DESCRIPTION
01.	Column (300 x 300)
02.	Brick Wall
03.	Windows
04.	Partitions
05.	Door
06.	Water Supply Pipe
07.	Storm Water Pipe
08.	Manhole 600 X 600 mm

- NOTES :
1. All Dimension are in Millimetre Otherwise Stated.
 2. All Levels are in metre and are with assume RL 100.0

FOR TENDER PURPOSE ONLY


TITLE : CLUSTER PLAN


DRAWN BY: VIA INFOTECH
DATE : NOV 2008
SCALE : 1:500

DWG NO : RANGH/CLUSTER SERVICE PLAN/01

BSUP

GROUND FLOOR SERVICE PLAN

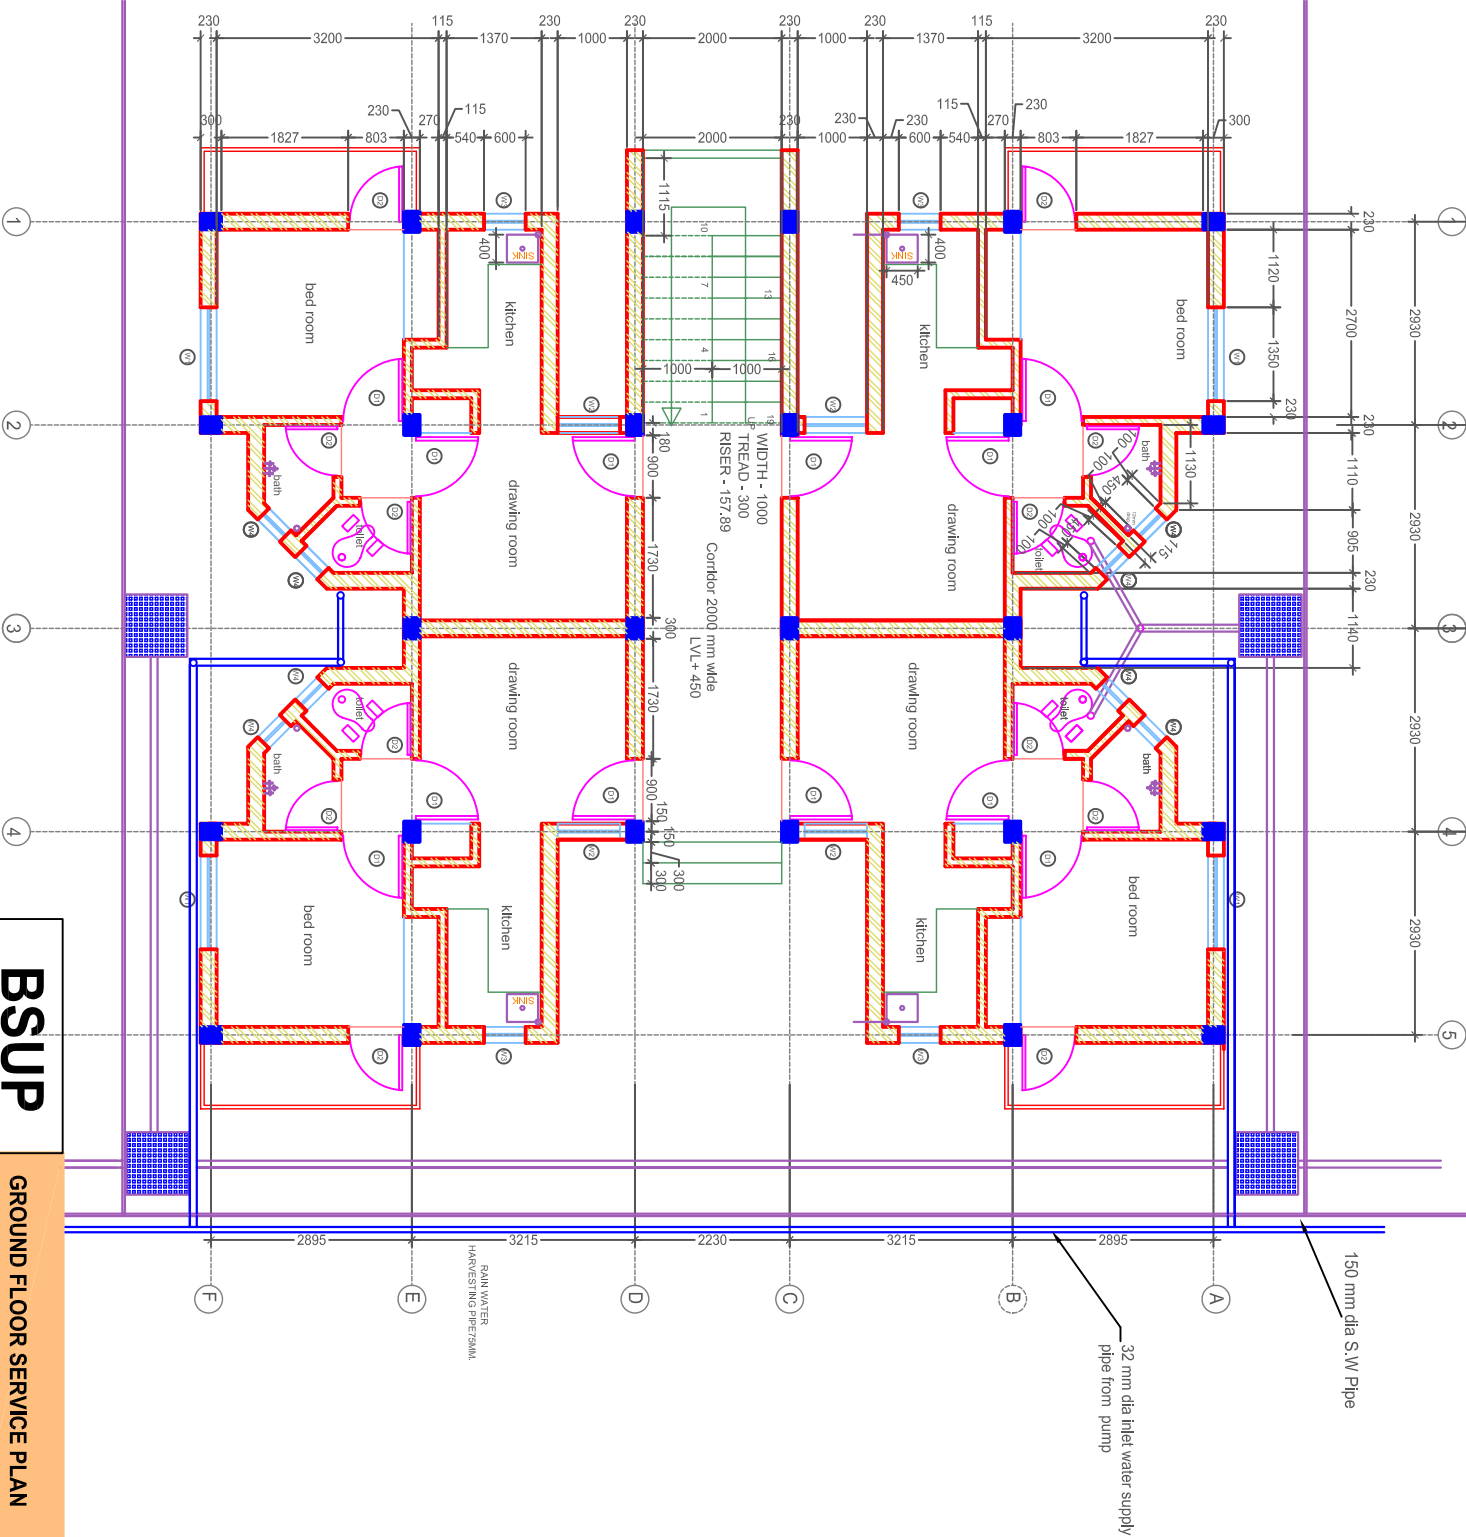

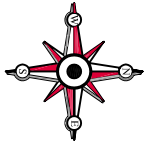

LEGEND	
SL.NO.	SYMBOL
DESCRIPTION	
01.	Columns (300 x 300)
02.	Brick Wall
03.	Windows
04.	Finishes

- NOTES :**
1. All Dimension are in Millimetre Otherwise Stated.
 2. All Levels are in metre and are with assume RL 100.0

FOR TENDER PURPOSE ONLY

TITLE : RANCHI PACKAGE 3.5, JNNURM


DRAWN BY: VIA INFOTECH	CHECKED BY: P.K.GROVER
DATE : NOV 2008	PACKAGE 3.5
SCALE :	
500 1000 1500 2500 4000	MM


DWG NO : RANCHI/GROUND FLOOR CLUSTER PLAN 001

REV : 0

BSUP

GROUND FLOOR CLUSTER PLAN

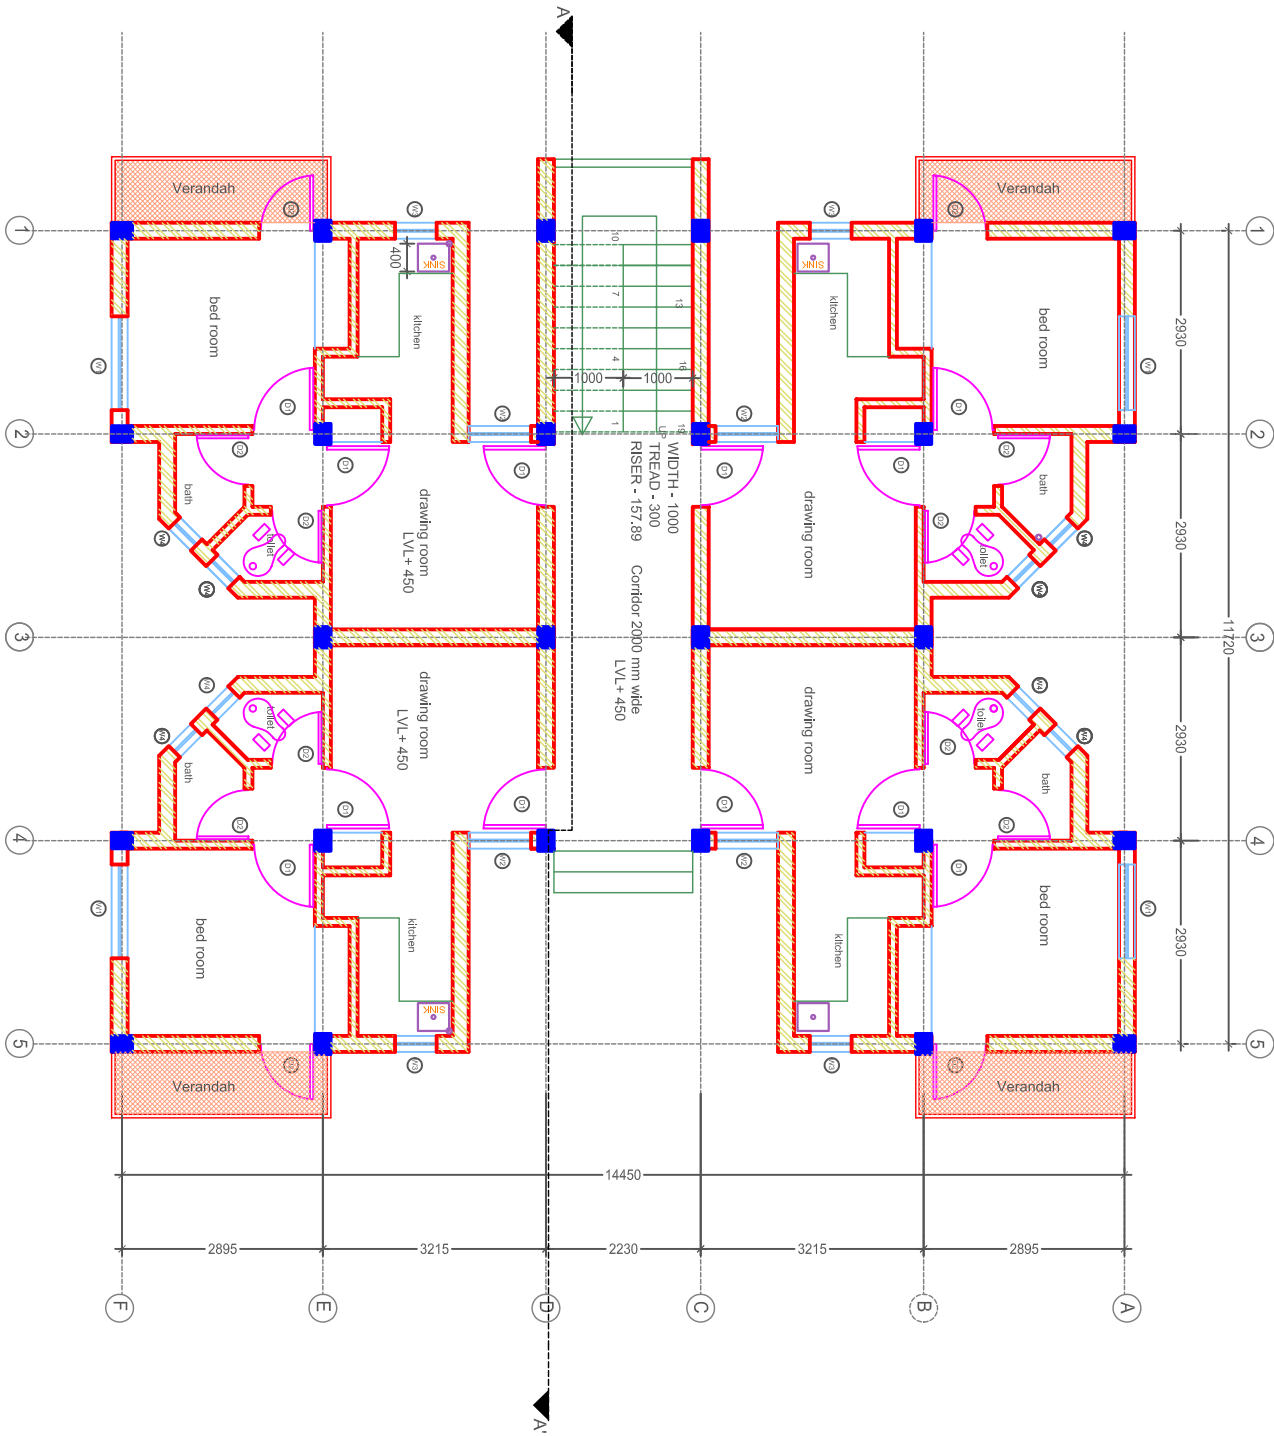

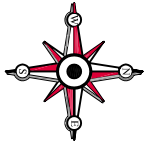

LEGEND	
SL.NO.	DESCRIPTION
01.	Columns (300 X 300)
02.	Brick Wall
03.	Windows
04.	Partitions
05.	Doors
06.	Water Supply pipe
07.	Storm water Pipe
08.	Manholes 600 X 600 mm

- NOTES :
1. All Dimension are in Millimetre Otherwise Stated.
 2. All Levels are in metre and are with assume RL 100.0

FOR TENDER PURPOSE ONLY


TITLE : RANCHI PACKAGE 3.5, JNNURM


DRAWN BY: VIA INFOTECH
DATE: NOV 2008
SCALE : 1:100
CHECKED BY: P.K.GROVER
PACKAGE 3.5
MM

DWG NO: RANCHI/ALL FLOOR CLUSTER PLAN-01

BSUP

ALL FLOOR CLUSTER PLAN

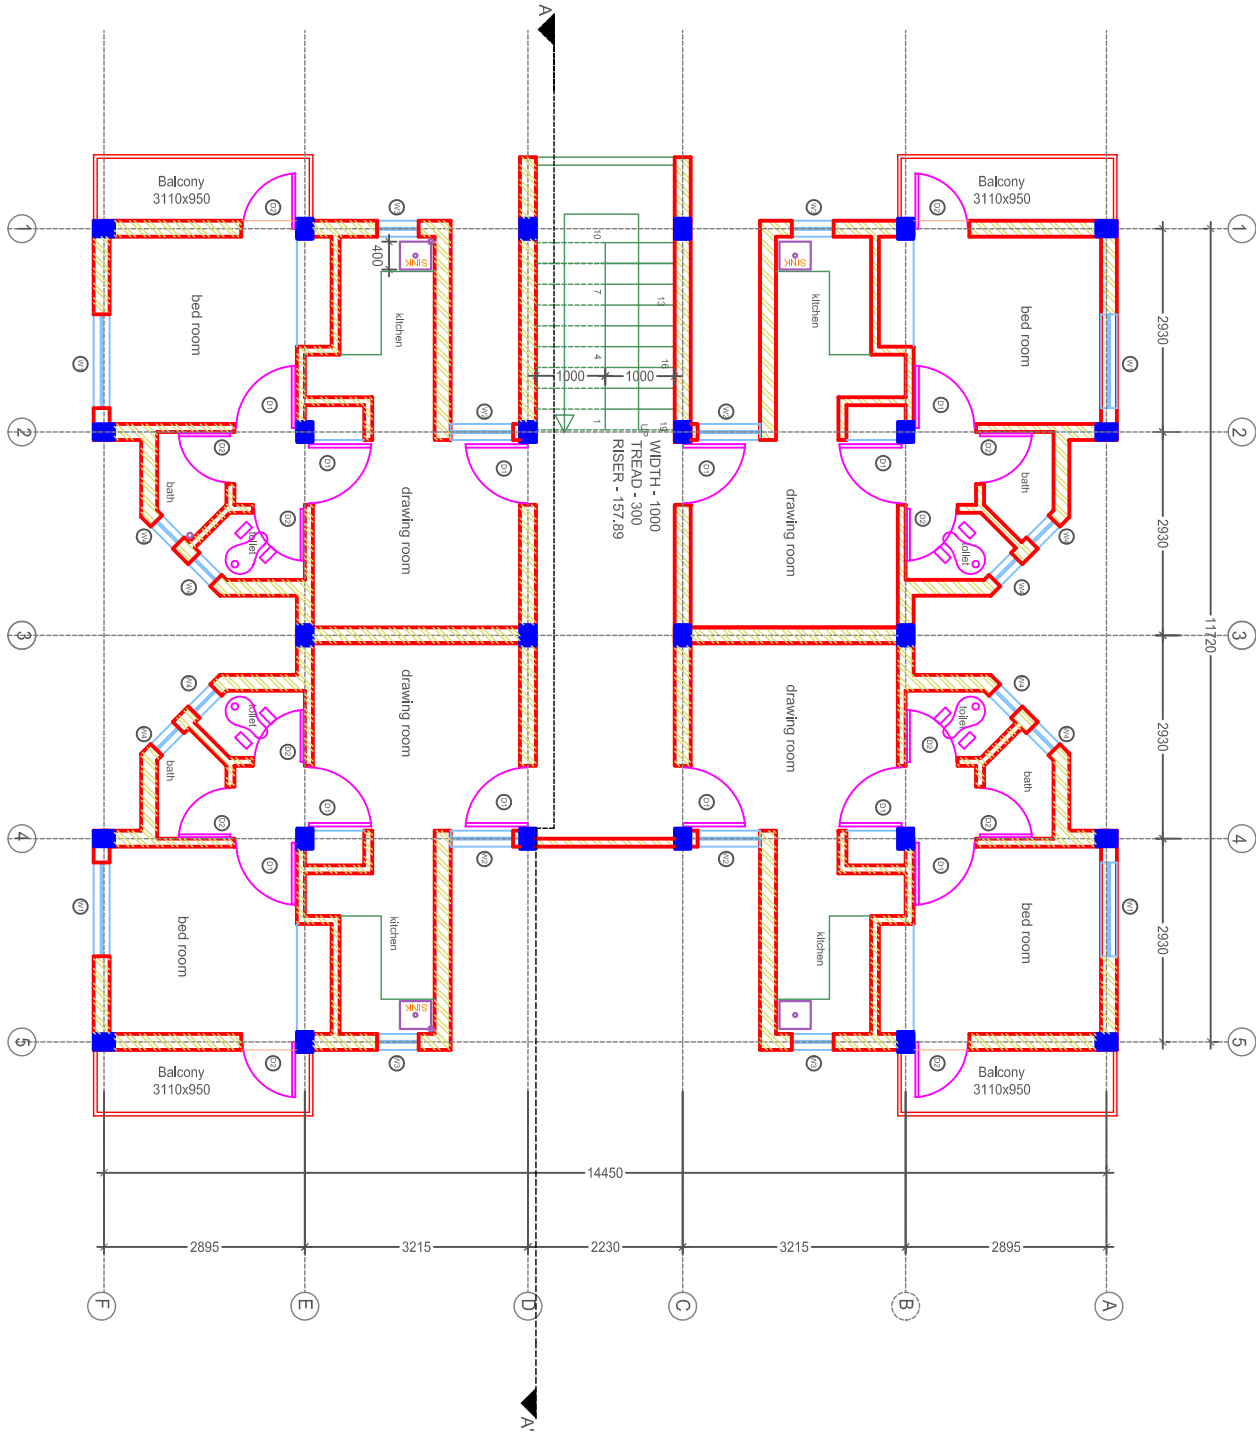

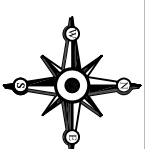


LEGEND	
SL.NO.	SYMBOL
01.	Column (300 X 300)
02.	Brick Wall
03.	Windows
04.	Feature
05.	Door
06.	Water Supply pipe
07.	Stone ware Pipe
08.	Manhole 600 X 600 mm
09.	Fea Point
10.	Wall Light
11.	5 AMP
12.	15 AMP
13.	Switch Board
14.	Bed Point
15.	1. V Point
16.	Exhaust Fan
17.	Conduits – 1.5 inch PVC pipe


NOTES :
1. All Dimension are in Millimetre Otherwise Stated.
2. All Levels are in metre and are with assume RL 100.0

FOR TENDER PURPOSE ONLY


TITLE : ELECTRICAL LAYOUT PLAN	
DRAWN BY: VIA INFOTECH	CHECKED BY: P.K. GROVER
DATE: NOV 2008	
SCALE: 500 0 500 1500 2500 MM	
PROJECT NO: RANGHIL ELECTRICAL LAYOUT 001	REV: 0

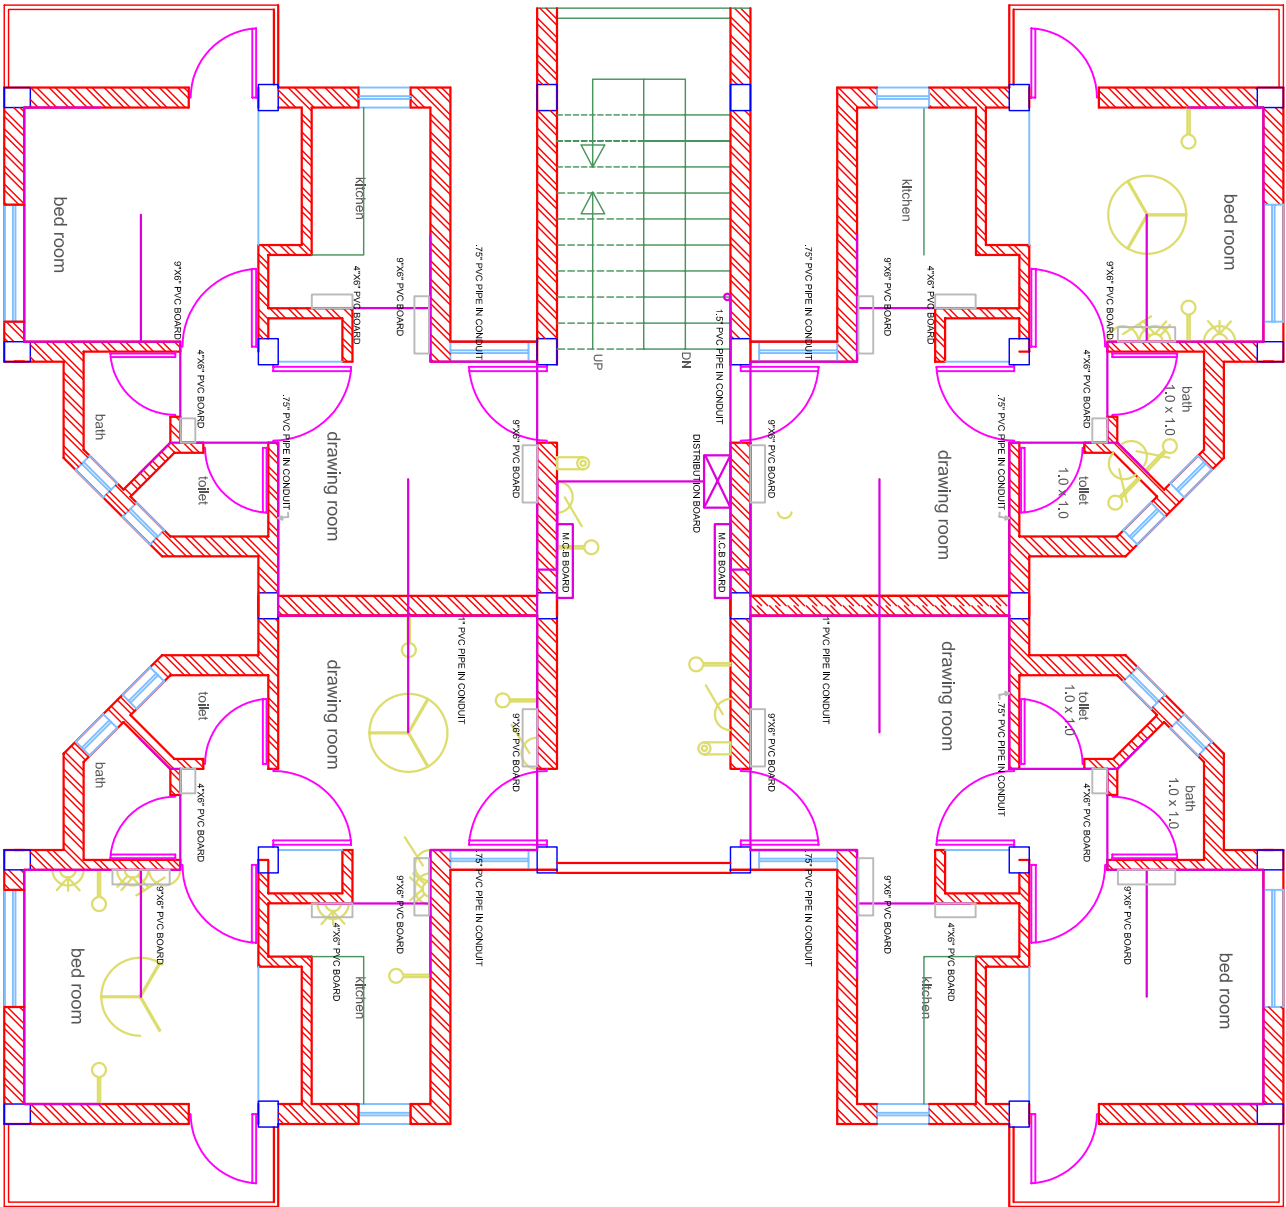

PVC PIPE IN CONDUIT LVL +2300 FROM FINISHED FLOOR LEVEL
ELECTRICAL CONDUIT LAYING PLAN

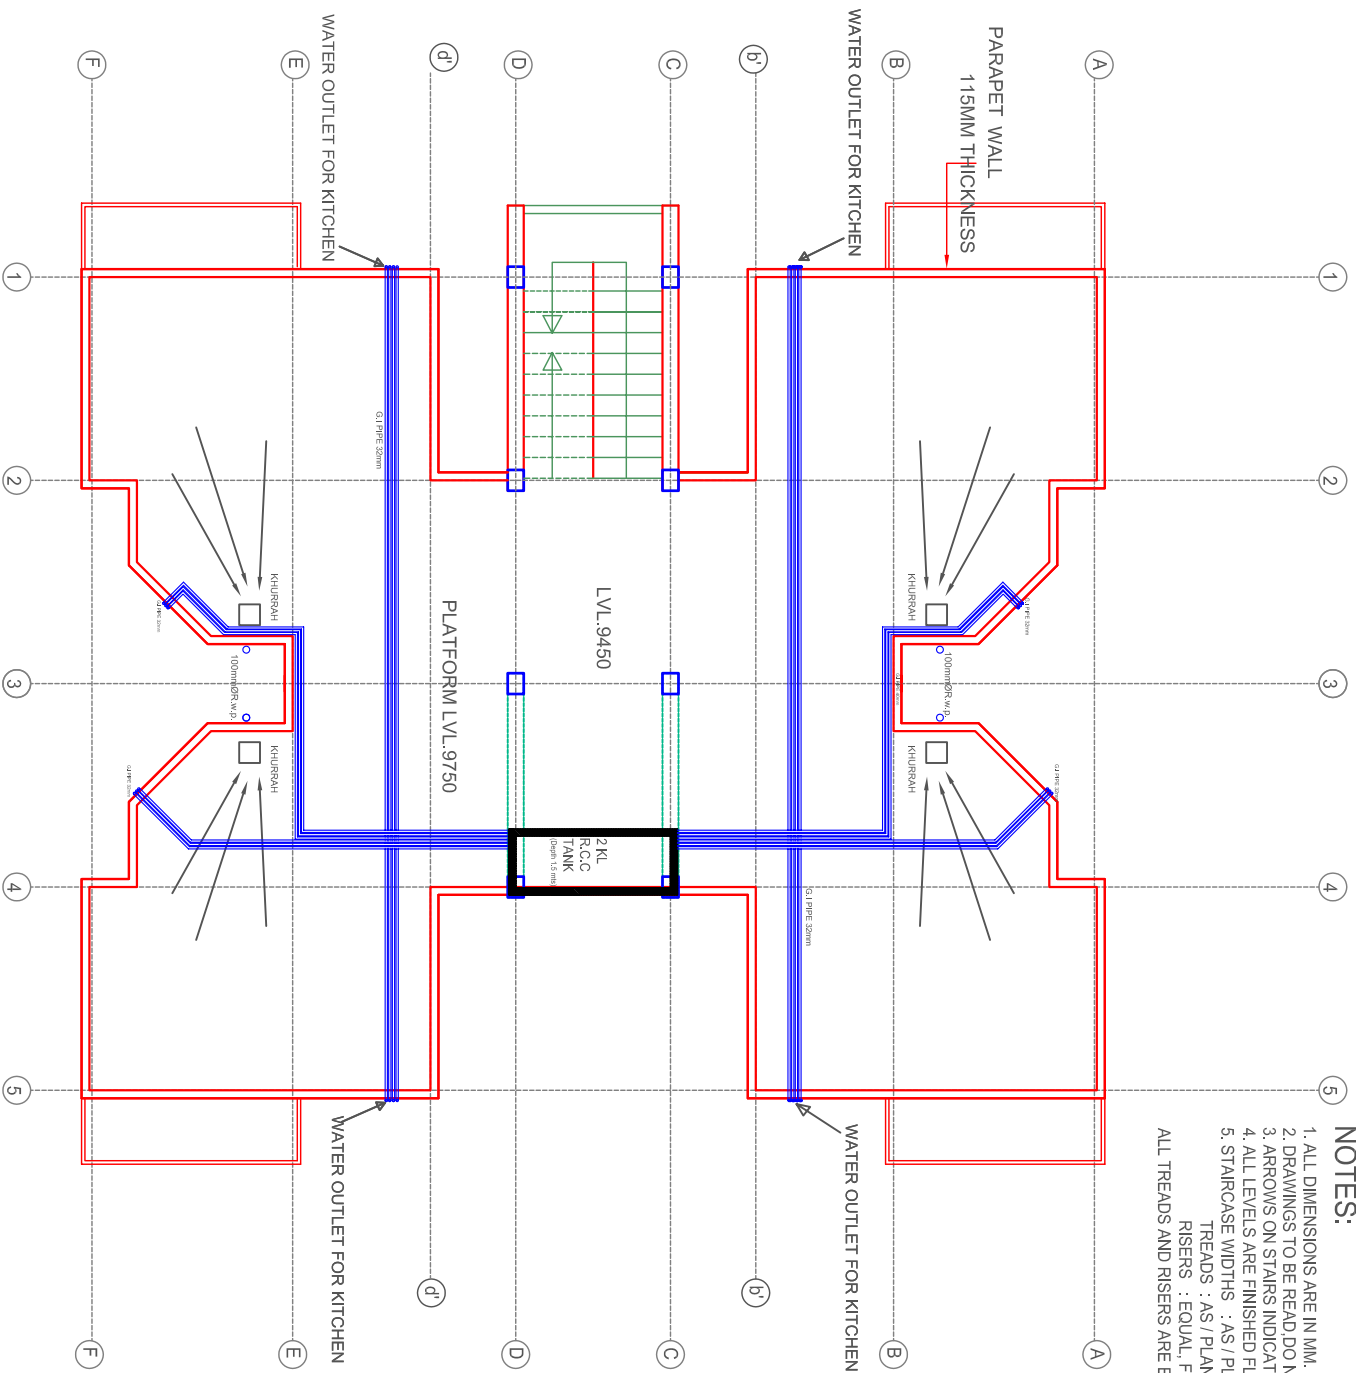

- ## NOTES:
1. ALL DIMENSIONS ARE IN MM.
 2. DRAWINGS TO BE READ DO NOT MEASURE.
 3. ARROWS ON STAIRS INDICATE UPWARD MOTION.
 4. ALL LEVELS ARE FINISHED FLOOR LEVELS.
 5. STAIRCASE WIDTHS : AS / PLANS
- TREADS : . AS / PLAN
RISERS : EQUAL FLR. TO FLR. AS / DRG.
ALL TREADS AND RISERS ARE EQUAL WITH DIMENSION.

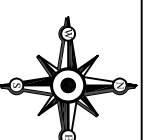

L E G E N D		S Y M B O L
S E R N O.	D E S C R I P T I O N	
1.	WATER TANKS (300 LITERS)	☉
2.	KHOURBAH	□
3.	WATER PIPES	≡

NOTES:

1. All Dimension are in Millimetre Otherwise Stated.
2. All Levels are in metre and are with assume RL 100.0

FOR TENDER PURPOSE ONLY

TITLE: TERRACE_G_1

DRAWN BY: VIA INFOTECH	CHECKED BY: P.K.GROVER
------------------------	------------------------


DATE : DEC 2008

SCALE: 500 0 500 1,500 2,500 4,500

DRG NO : RANCH/TERRACE PLAN G+1 /01	REV : 0
-------------------------------------	---------

BSUP

TERRACE PLAN G+1

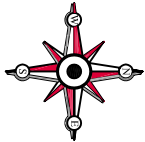


NOTES:

1. ALL DIMENSIONS ARE IN MM.
 2. DRAWINGS TO BE READ DO NOT MEASURE.
 3. ARROWS ON STAIRS INDICATE UPWARD MOTION.
 4. ALL LEVELS ARE FINISHED FLOOR LEVELS.
 5. STAIRCASE WIDTHS : AS / PLANS
- TREADS : AS / PLAN
RISERS : EQUAL, FLR. TO FLR. AS / DRG.
ALL TREADS AND RISERS ARE EQUALS WITH DIMENSION.

SL.NO.	DESCRIPTION	SYMBOL
1.	WATER TANKS (300 LITRES)	
2.	KHURBAH	
3.	WATER PIPES	

NOTES :

1. All Dimension are in Millimetre Otherwise Stated.
2. All Levels are in metre and are with assume RL 100.0

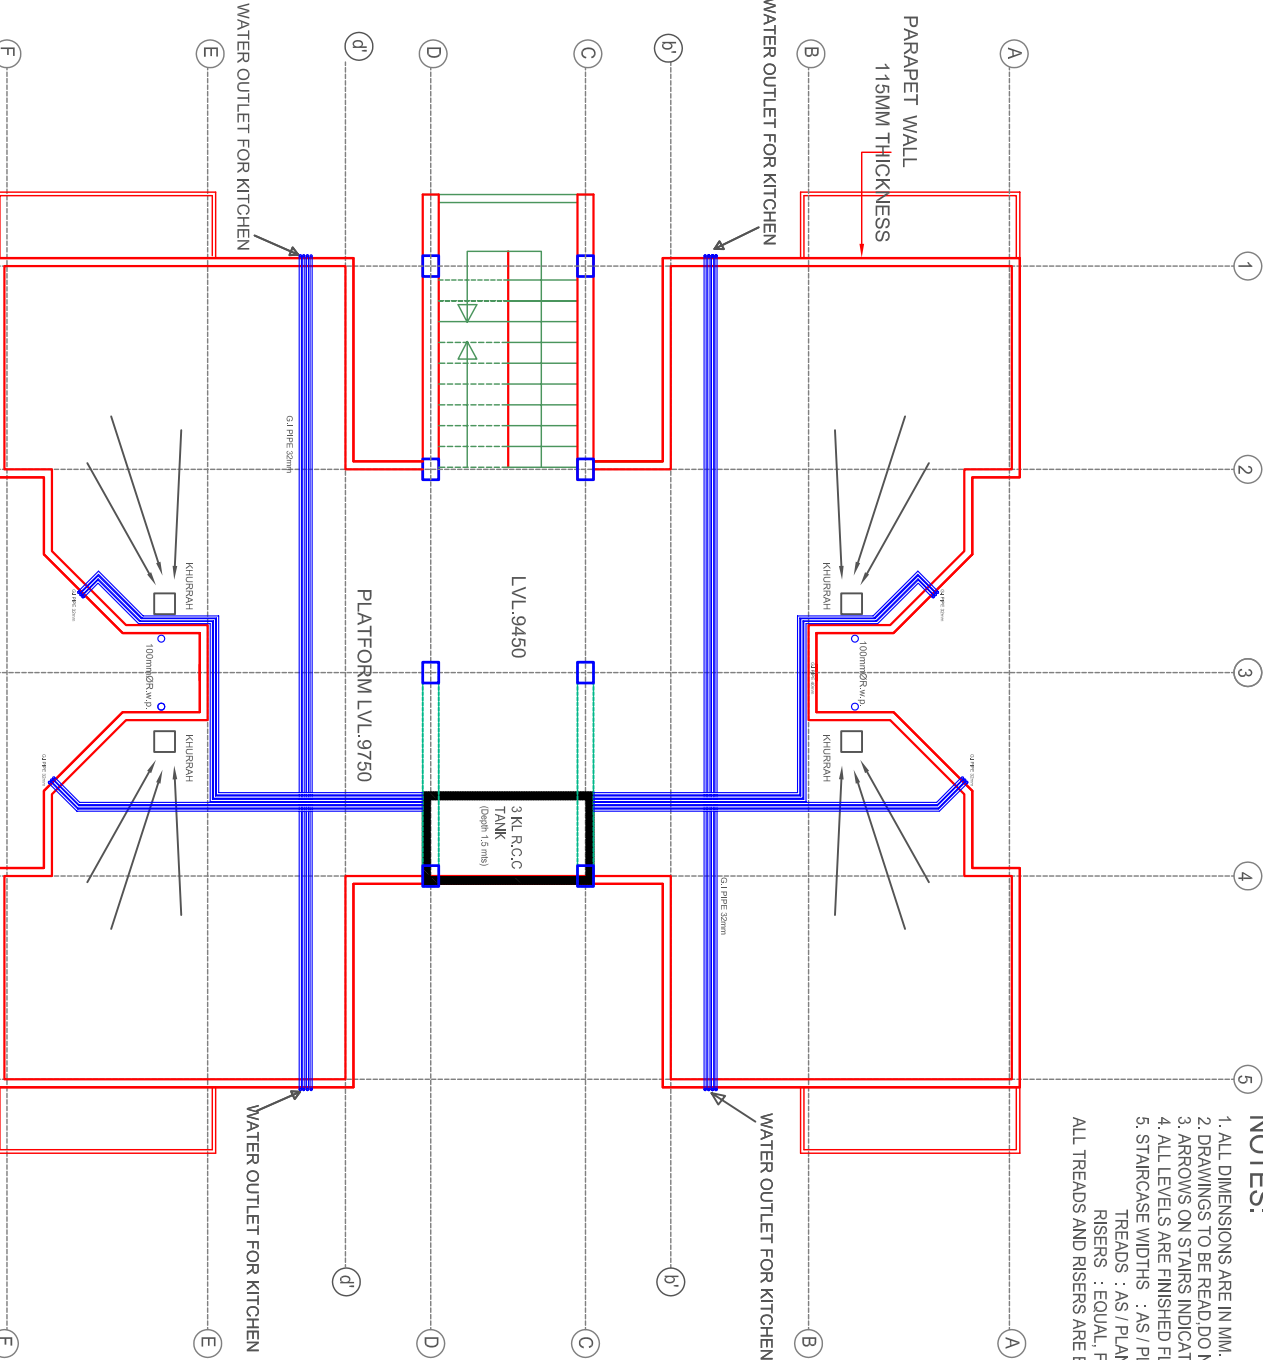


BSUP

TERRACE PLAN G+2

FOR TENDER PURPOSE ONLY


TITLE : TERRACE PLAN G+2

DRAWN BY: VIA INFOTECH	CHECKED BY: P.K.GROVER
DATE: MAY 2008	
SCALE :	
DWG NO : RANGH/TERRACE PLAN G+2 01	REV : 0

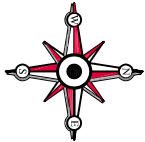

LEGEND	
SL.NO.	DESCRIPTION
1.	WATER TANKS (300 LITRES)
2.	KHURBAH
3.	WATER PIPES

- NOTES:**
1. ALL DIMENSIONS ARE IN MM.
 2. DRAWINGS TO BE READ DO NOT MEASURE.
 3. ARROWS ON STAIRS INDICATE UPWARD MOTION.
 4. ALL LEVELS ARE FINISHED FLOOR LEVELS.
 5. STAIRCASE WIDTHS : AS / PLANS
- TREADS : AS / PLAN
RISERS : EQUAL, FLR. TO FLR. AS / DRG.
ALL TREADS AND RISERS ARE EQUALS WITH DIMENSION.

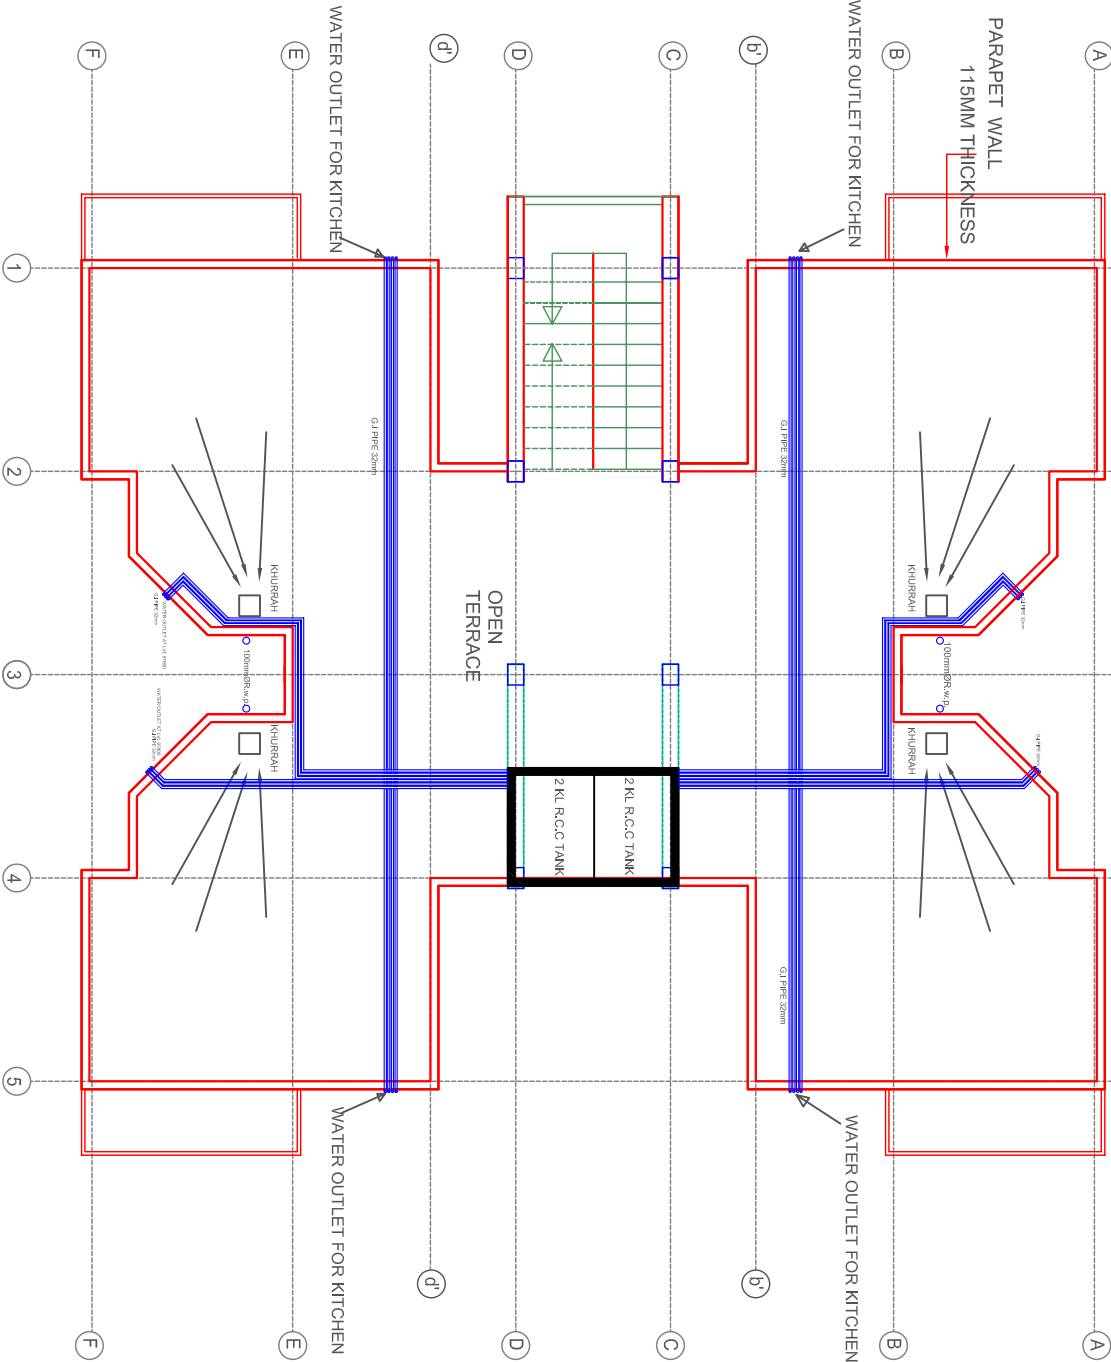


- NOTES :**
1. All Dimension are in Millimetre Otherwise Stated.
 2. All Levels are in metre and are with assume RL 100.0

FOR TENDER PURPOSE ONLY

TITLE : TERRACE PLAN G+3

DRAWN BY: VIA INPOTCH	CHECKED BY: P.K.GROVER
DATE: MAY 2008	PHASE: 1
SCALE: 1:1	MM
DWG NO: RANGH/TERRACE PLAN G+3 01	REV: 0

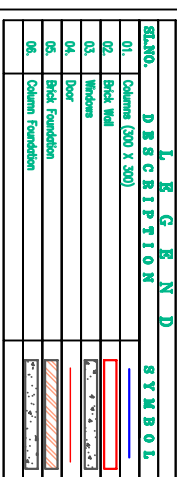


NOTES :

1. All Dimension are in Millimetre Otherwise Stated.
2. All Levels are in metre and are with assume RL 100.0

TITLE: SECTION G+2

BSUP

SECTION G+2

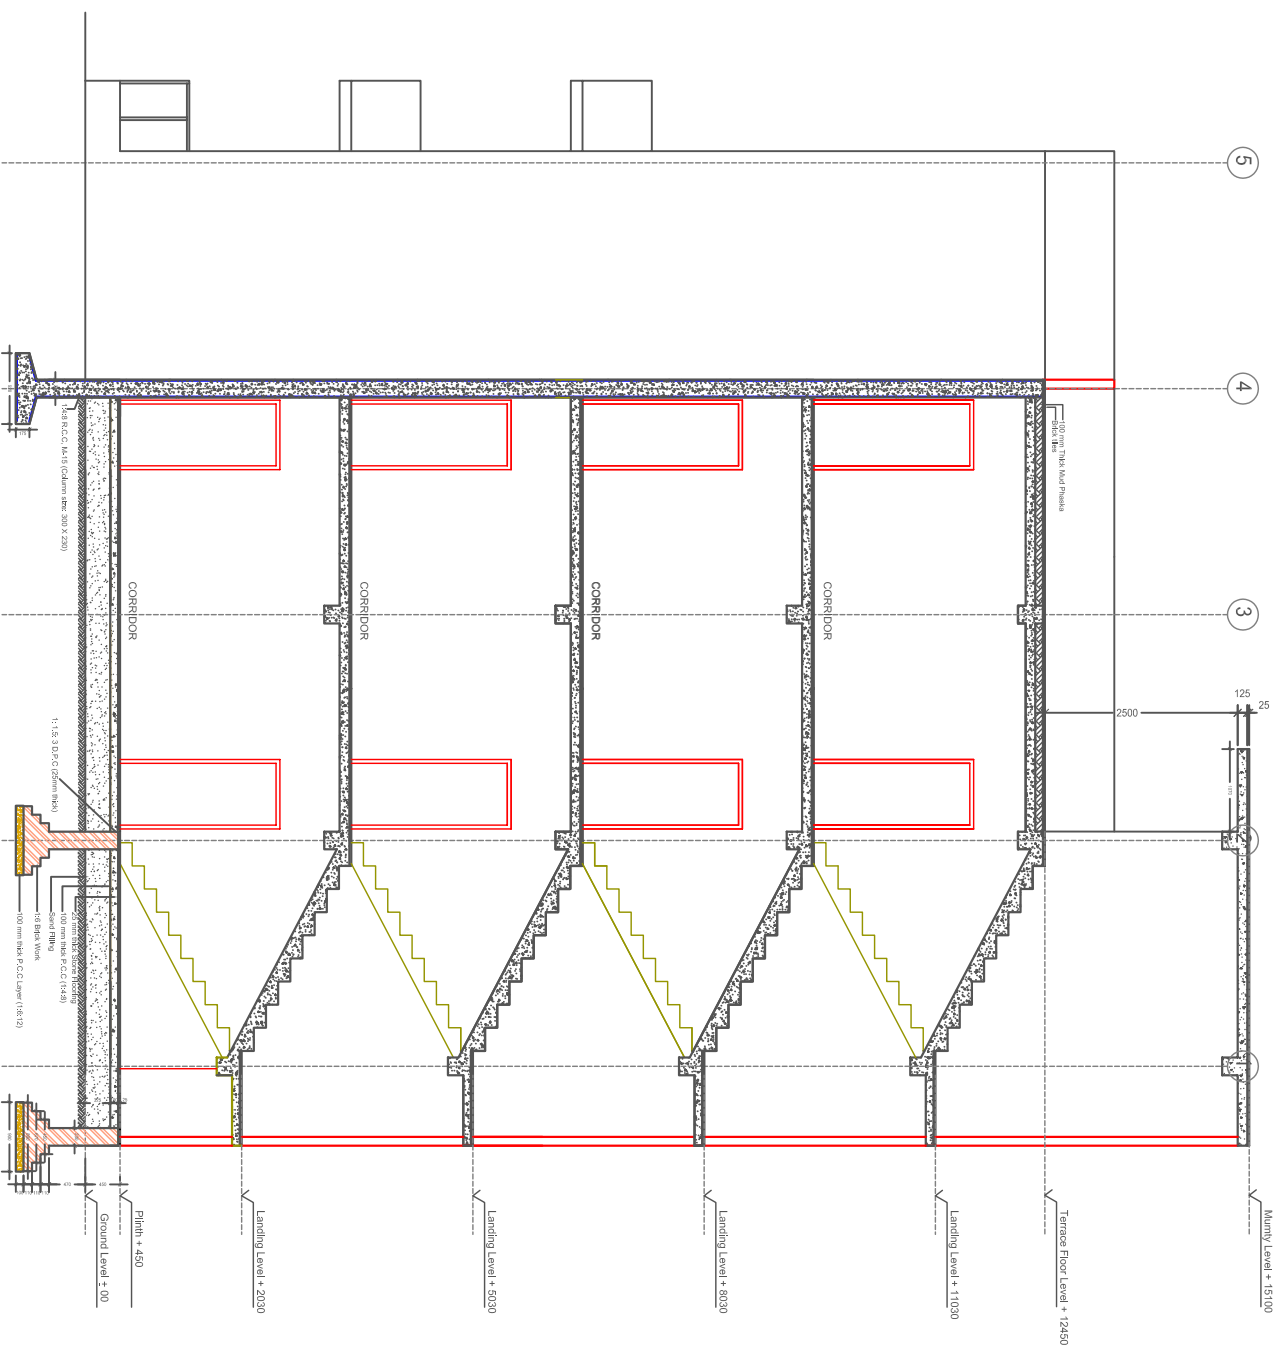


NOTES:

1. All Dimension are in Millimetre Otherwise Stated.


2. All Levels are in metre and are with assume RL 100.0.0.

1. All Dimension are in Millimetre Otherwise Stated.
2. All Levels are in metre and are with assume RL 100.0.

TITLE: SECTION G+3

DRAWN BY: VIA INFOTECH	CHECKED BY: P.K GROVER
DATE: DEC 2008	
SCALE: 	
DIRG NO: RAJNCH/SECTION G-4/ 001	REV: 0

SECTION G+3

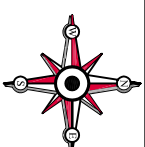

- NOTES :**
- 1. All Dimension are in Millimetre Otherwise Stated.
 - 2. All Levels are in metre and are with assume RL 100.0

FOR TENDER PURPOSE ONLY

TITLE : ELEVATION G+2

DRAWN BY: VIA INPOTEC


CHECKED BY: P.K.GROVER

DATE : DEC 2008

SCALE :  MM

DWG NO: RANGCHU ELEVATION G+2.01


REV : 0

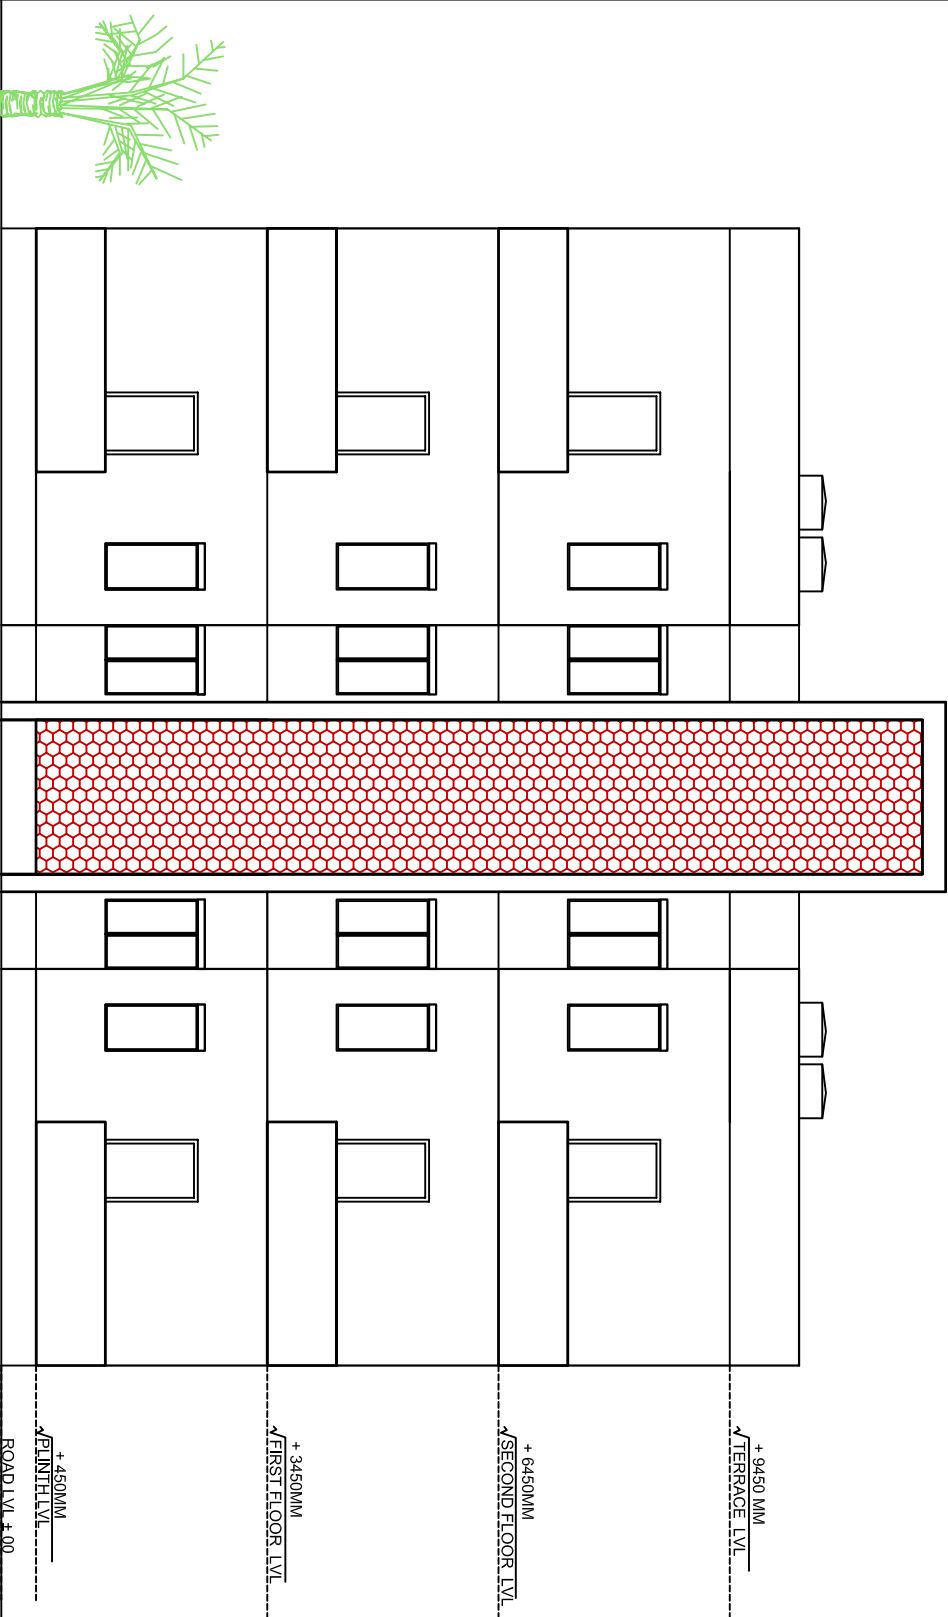

REAR ELEVATION G+2

BSUP

ELEVATION G+2

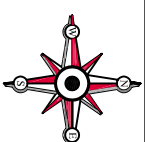

NOTES :

1. All Dimension are in Millimetre Otherwise Stated.
2. All Levels are in metre and are with assume RL 100.0

FOR TENDER PURPOSE ONLY


TITLE : ELEVATION G+3

DRAWN BY: VIA INPOTECI CHECKED BY: P.K.GROVER

DATE : DEC 2008

SCALE :

DWG NO: RANGCHU ELEVATION G+3 01 REV : 0

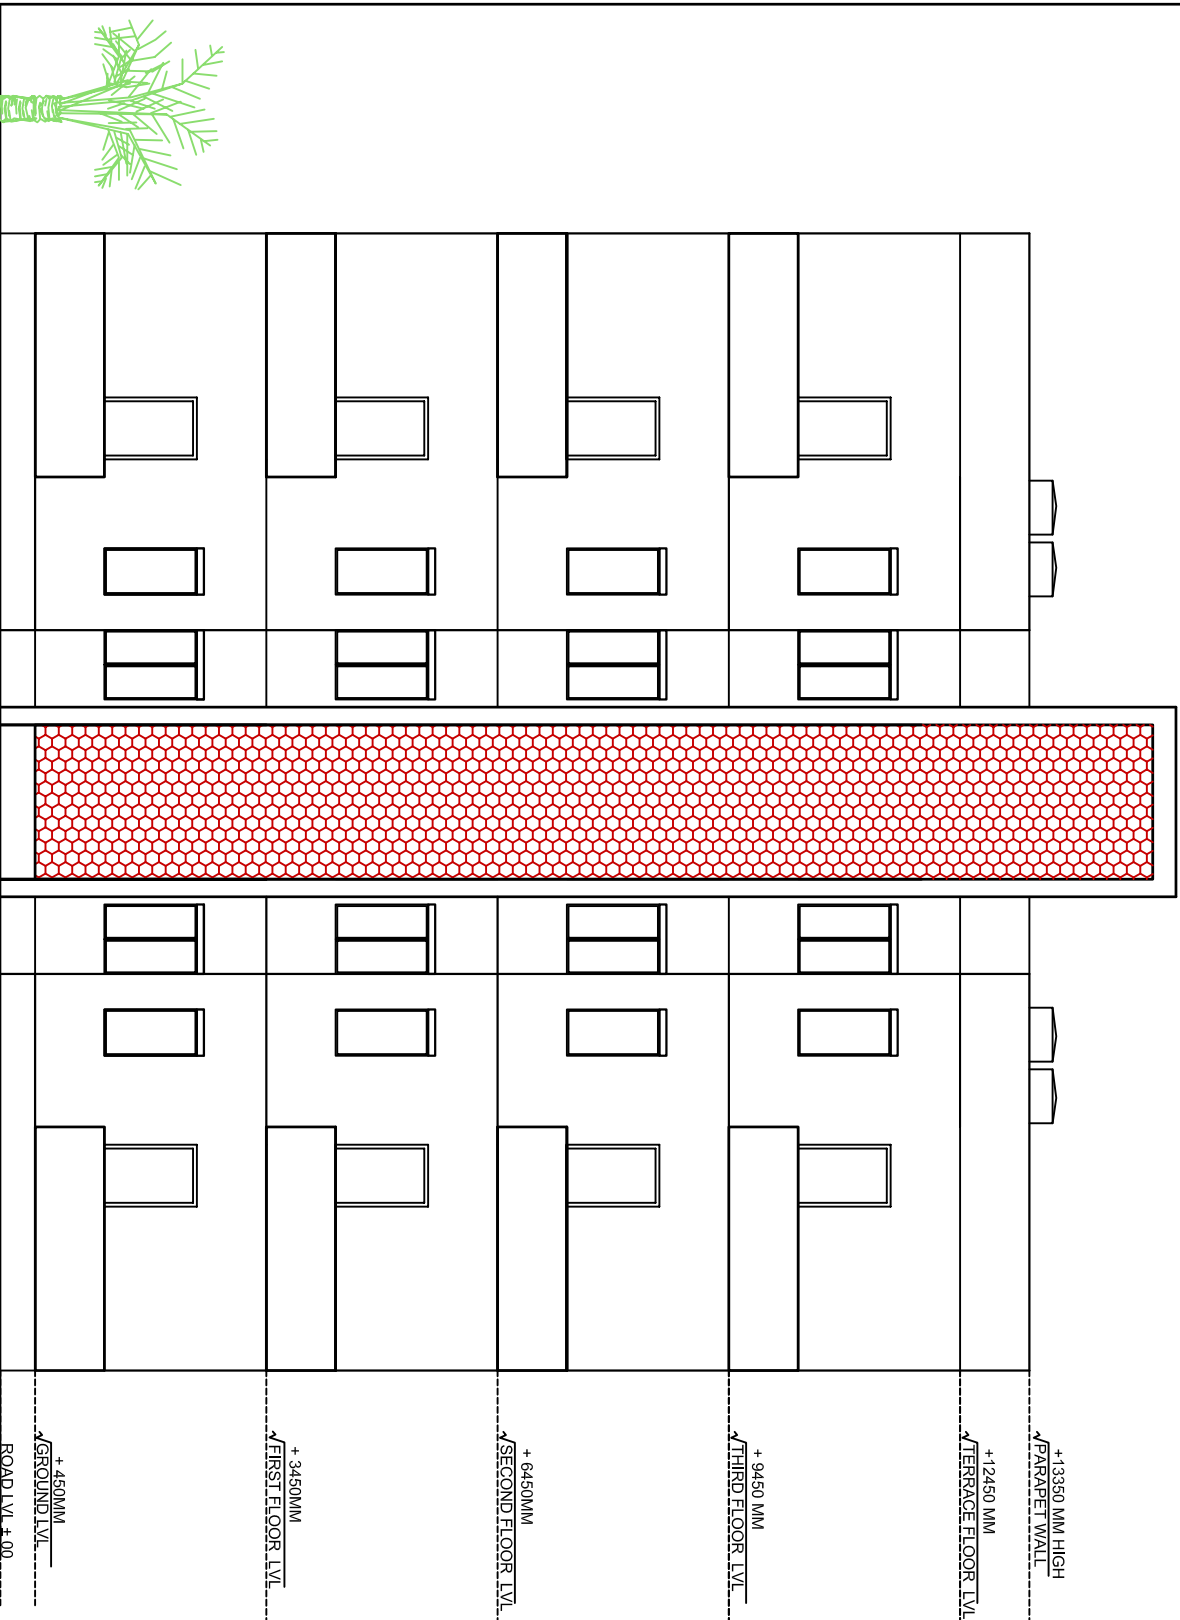

REAR ELEVATION G+3

BSUP

ELEVATION G+3