



Project		D: 1200 X 2100 (2 shutter)		<div><div></div><div>Drg. No.</div></div>	
BSUP		D1: 900x1800 (1 shutter)			
Sheet Title		W: 1300x1500 (2 shutter)		<div>Scale</div> <div>APP</div>	
		V: 700 X 500			
LIVELIHOOD CENTRE (SMALL)- GROUND FLOOR PLAN				LC1	
		Date 03-02-2008			

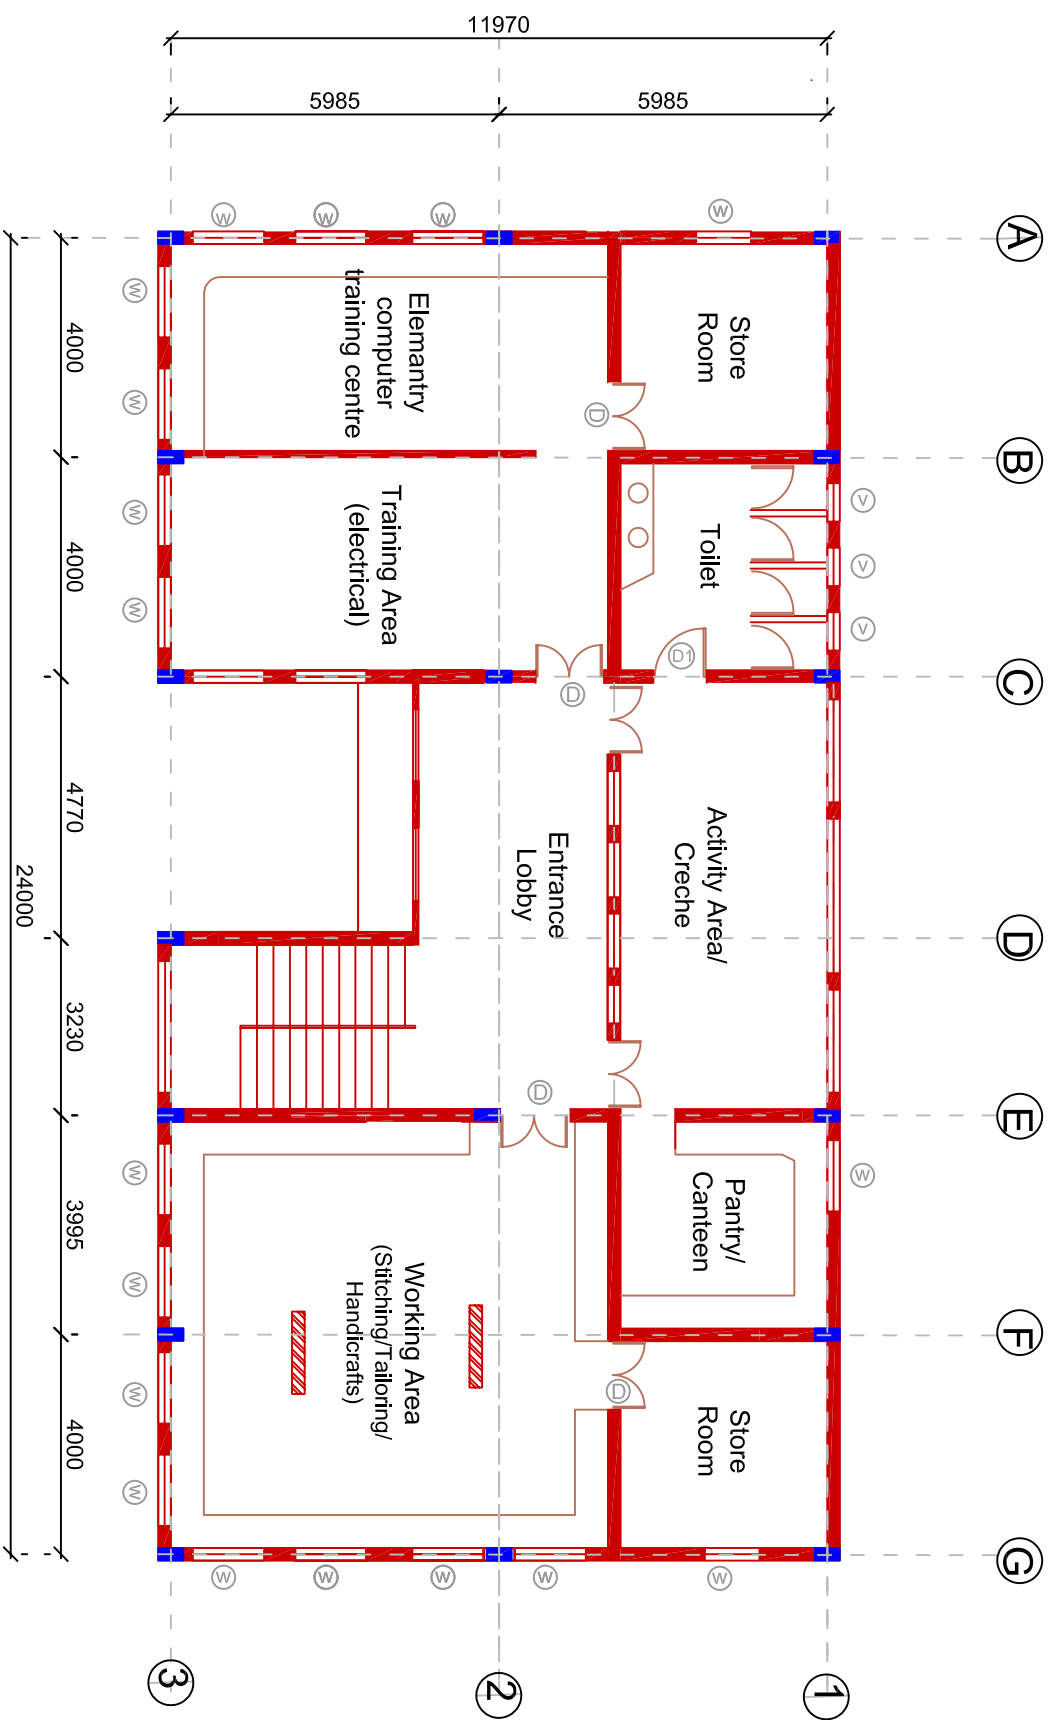


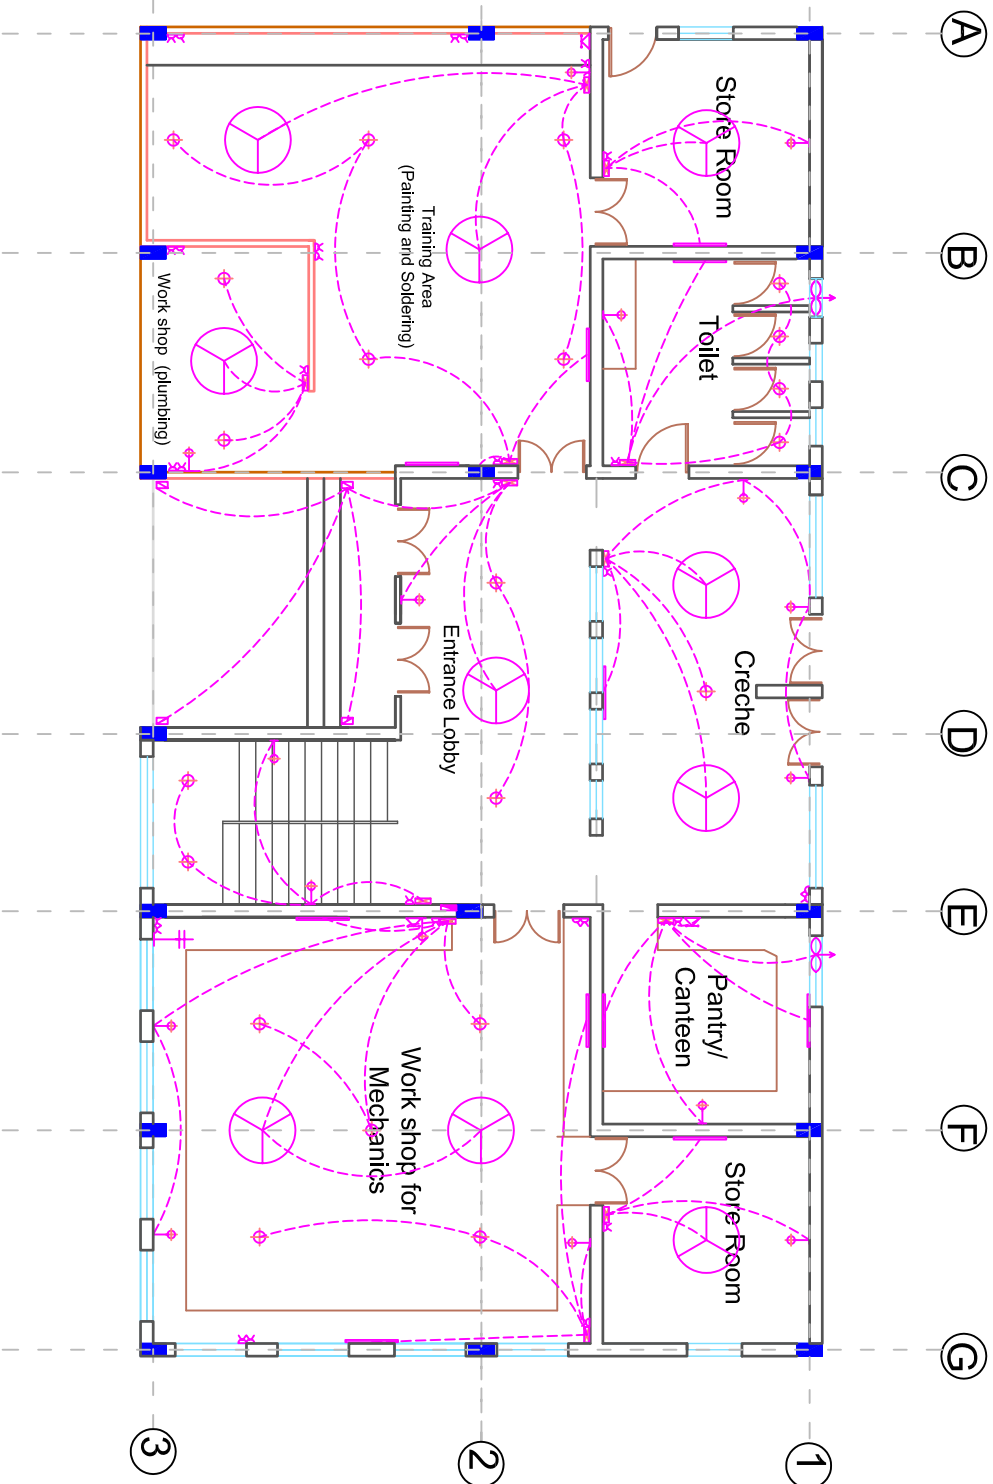
BUILT UP ON FIRST FLOOR : 280 Sq. Mt

Project		Drg. No.	
BSUP		LC1	
Sheet Title		Scale APP	
LIVELIHOOD CENTRE (SMALL)- FIRST FLOOR PLAN		Date 03-02-2008	
		INFRASTRUCTURE PROFESSIONAL ENTERPRISE Pvt. Ltd.	
		C-2 GREEN PARK EXTENSION, DELHI	

D : 1200 X 2100 (2 shutter)
D1: 900X1800 (1 shutter)
W: 1300X1500 (2 shutter)
V: 700 X 500

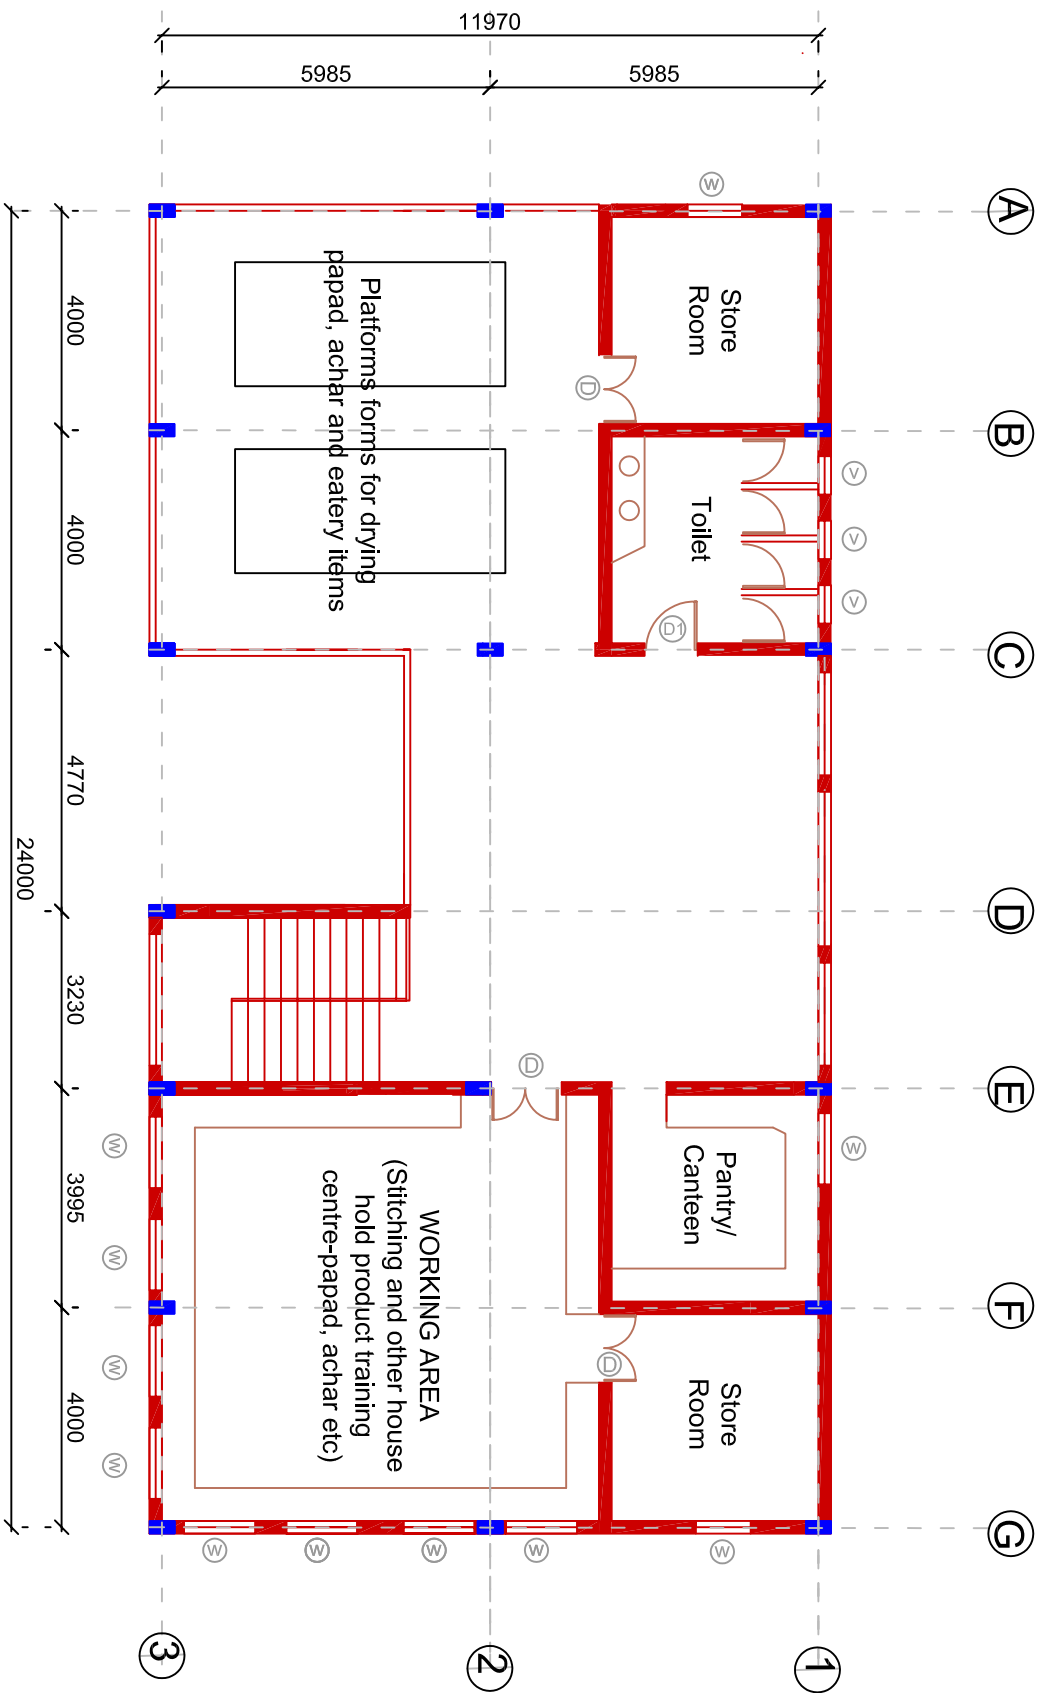

Project		D: 1200 X 2100 (2 shutter)		<div></div>	Drg. No.
BSUP		D1: 900X1800 (1 shutter)			
Sheet Title		W: 1300X1500 (2 shutter)			
LIVELIHOOD CENTRE (SMALL)- SECOND FLOOR PLAN		V: 700 X 500		Scale	APP
				Date	03-02-2008
				INFRASTRUCTURE PROFESSIONAL ENTERPRISE PVT. LTD.	
				C- 2 GREEN PARK EXTENSION, DELHI	




LEGEND FOR GROUND FLOOR

Symbol	No.	Description
	10	CEILING FAN
	2	EXHAUST FAN
	3	TELEPHONE POINT
	12	SWITCH BOARD WITH 5 AMP.
	24	20 AMP SWITCH & SOCKET
	9	5 -15 AMP SWITCH & SOCKET
	16	WALL BRACKET LIGHT
	20	CEILING LIGHT
	1	T.V./ CABLE POINT
	4	FOOT LIGHT
	1	MCB
	11	36 OR 40 WATT FLUORESCENT TUBE

NOTE:

1. ALL POINTS OVER FURNITURE SHALL BE 3" FROM TOP OF FURNITURE
2. FOR FURNITURE SIZE- REFER ARCHITECTURAL PLAN
3. HEIGHT OF BED SIDE TABLE=1'6", STUDY TABLE-2'6", RECEPTION TABLES-2'6"

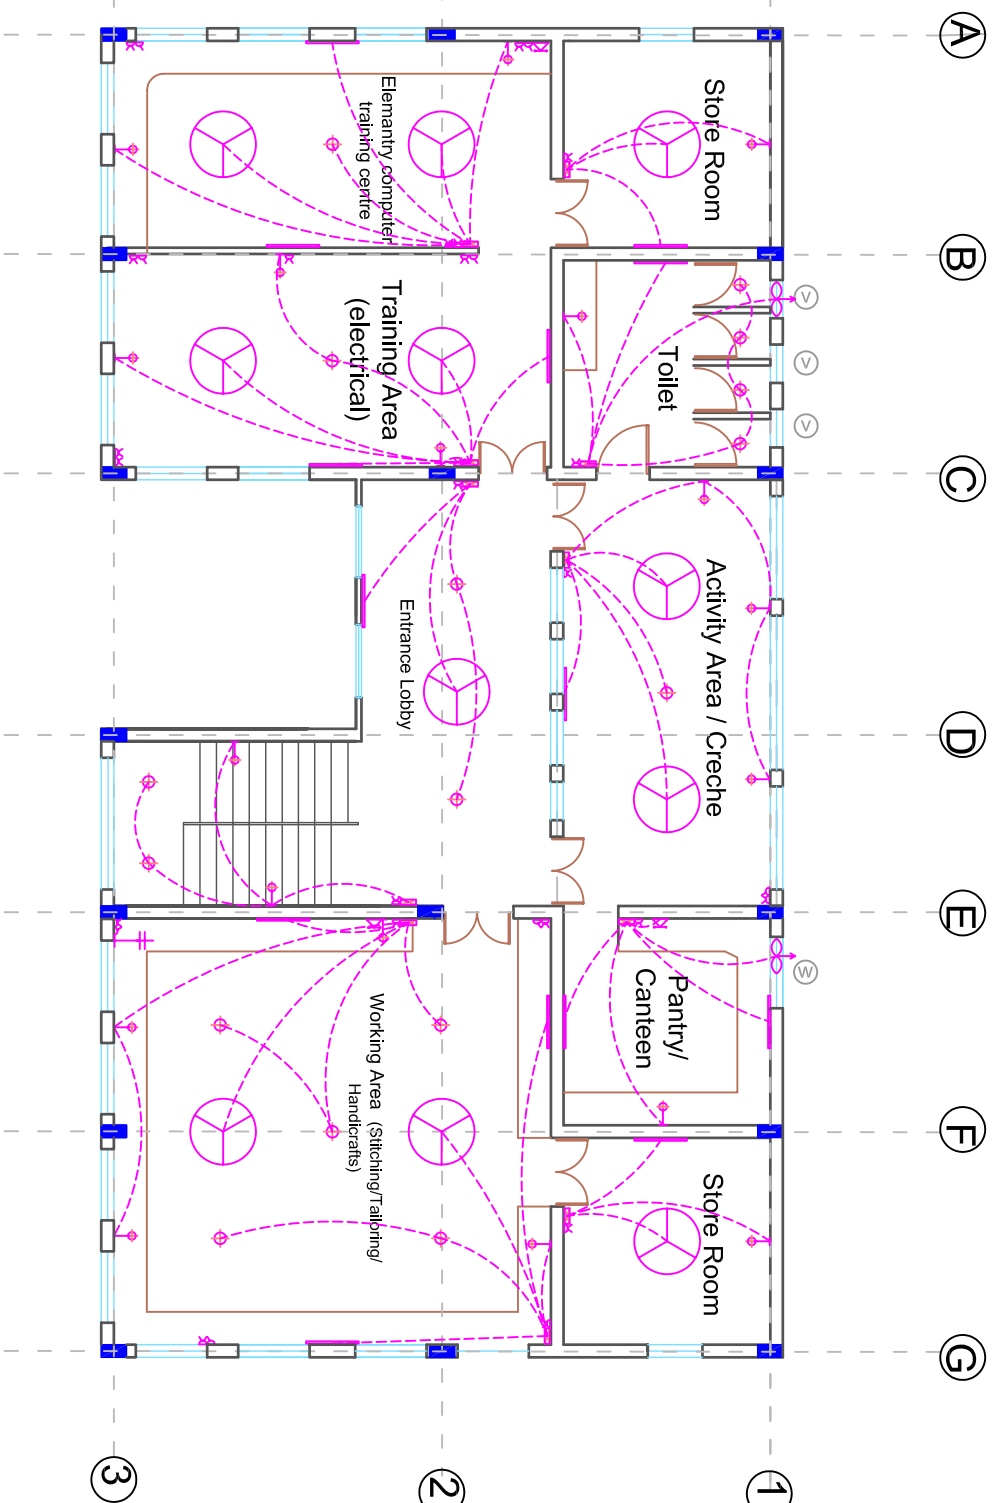

LEGEND FOR FIRST FLOOR

Symbol	No.	Description
	11	CEILING FAN
	2	EXHAUST FAN
	3	TELEPHONE POINT
	11	SWITCH BOARD WITH 5 AMP.
	22	20 AMP SWITCH & SOCKET
	8	5 -15 AMP SWITCH & SOCKET
	18	WALL BRACKET LIGHT
	12	CEILING LIGHT
	1	T.V./ CABLE POINT
	0	FOOT LIGHT
	0	MCB
	13	36 OR 40 WATT FLUORESCENT TUBE

NOTE:


1. ALL POINTS OVER FURNITURE SHALL BE 3" FROM TOP OF FURNITURE
2. FOR FURNITURE SIZE- REFER ARCHITECTURAL PLAN
3. HEIGHT OF BED SIDE TABLE=1'6", STUDY TABLE-2'6", RECEPTION TABLES-2'6"

Project
BSUP
Sheet Title
LIVELIHOOD CENTRE (SMALL)- FIRST FLOOR PLAN

BUILT UP ON FIRST
FLOOR : 280 Sq Mt

Dwg. No.
LC1
Scale APP
Date 03-02-2008

INFRASTRUCTURE PROFESSIONAL ENTERPRISE Pvt. Ltd.
C-2 GREEN PARK EXTENSION, DELHI

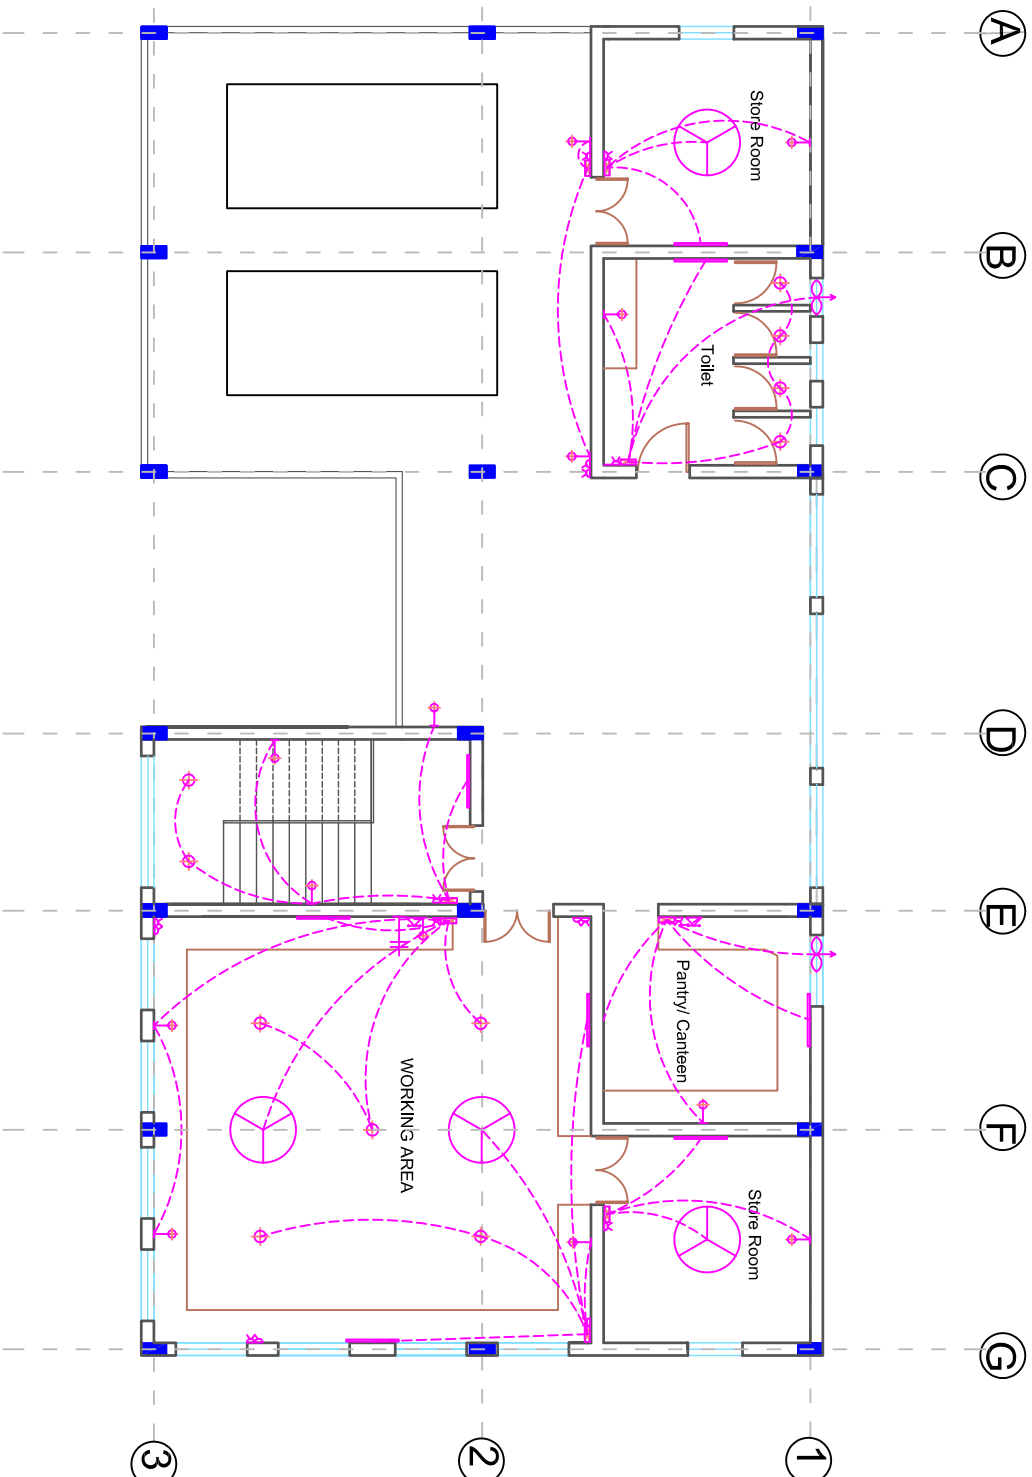

LEGEND FOR TERRACE FLOOR

Symbol	Length (in mm)	Description
	4	CEILING FAN
	2	EXHAUST FAN
	2	TELEPHONE POINT
	8	SWITCH BOARD WITH 5 AMP.
	12	20 AMP SWITCH & SOCKET
	4	5 -15 AMP SWITCH & SOCKET
	10	WALL BRACKET LIGHT
	11	CEILING LIGHT
	1	T.V./ CABLE POINT
	0	FOOT LIGHT
	0	MCB
	8	36 OR 40 WATT FLUORESCENT TUBE

NOTE:

1. ALL POINTS OVER FURNITURE SHALL BE 3" FROM TOP OF FURNITURE
2. FOR FURNITURE SIZE- REFER ARCHITECTURAL PLAN
3. HEIGHT OF BED SIDE TABLE=1'6", STUDY TABLE-2'6", RECEPTION TABLES-2'6"

Project

BSUP

Sheet Title

LIVELIHOOD CENTRE (SMALL)- SECOND FLOOR PLAN


Drg. No.

LC1

Scale APP

Date 03-02-2008

INFRASTRUCTURE PROFESSIONAL ENTERPRISE Pvt. Ltd.
C-2 GREEN PARK EXTENSION, DELHI

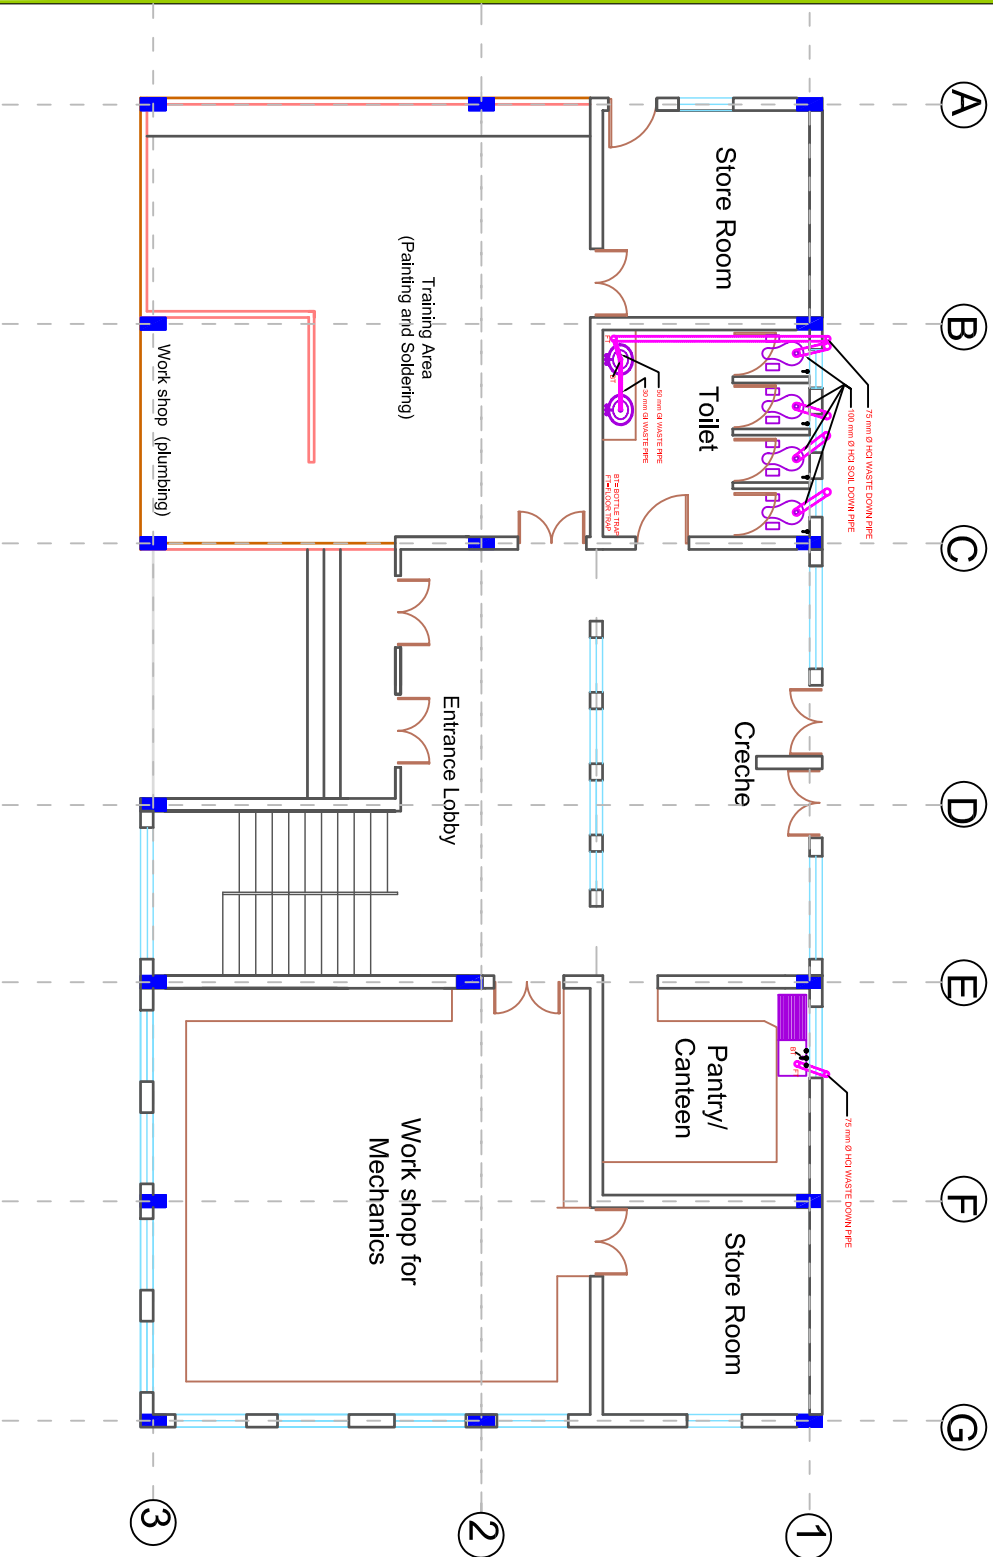

LEGEND FOR GROUND FLOOR		
Symbol	Length in mm/Km	Description
	4500	75 mm Ø HCI WASTE DOWN PIPE
	2400	100 mm Ø HCI WASTE DOWN PIPE
	7	Water Traps
FT	2	Floor Trap
BT	3	BoilerTrap

NOTE:
1. ONLY INTERNAL LENGTHS ARE MENTIONED IN THE LEGEND

Project

BSUP

Sheet Title

BUILT UP ON GROUND FLOOR : 300 Sq Mt

Drig. No.

LC1

Scale


APP

Date

03-02-2008

INFRASTRUCTURE PROFESSIONAL ENTERPRISE Pvt. Ltd.

C-2 GREEN PARK EXTENSION, DELHI

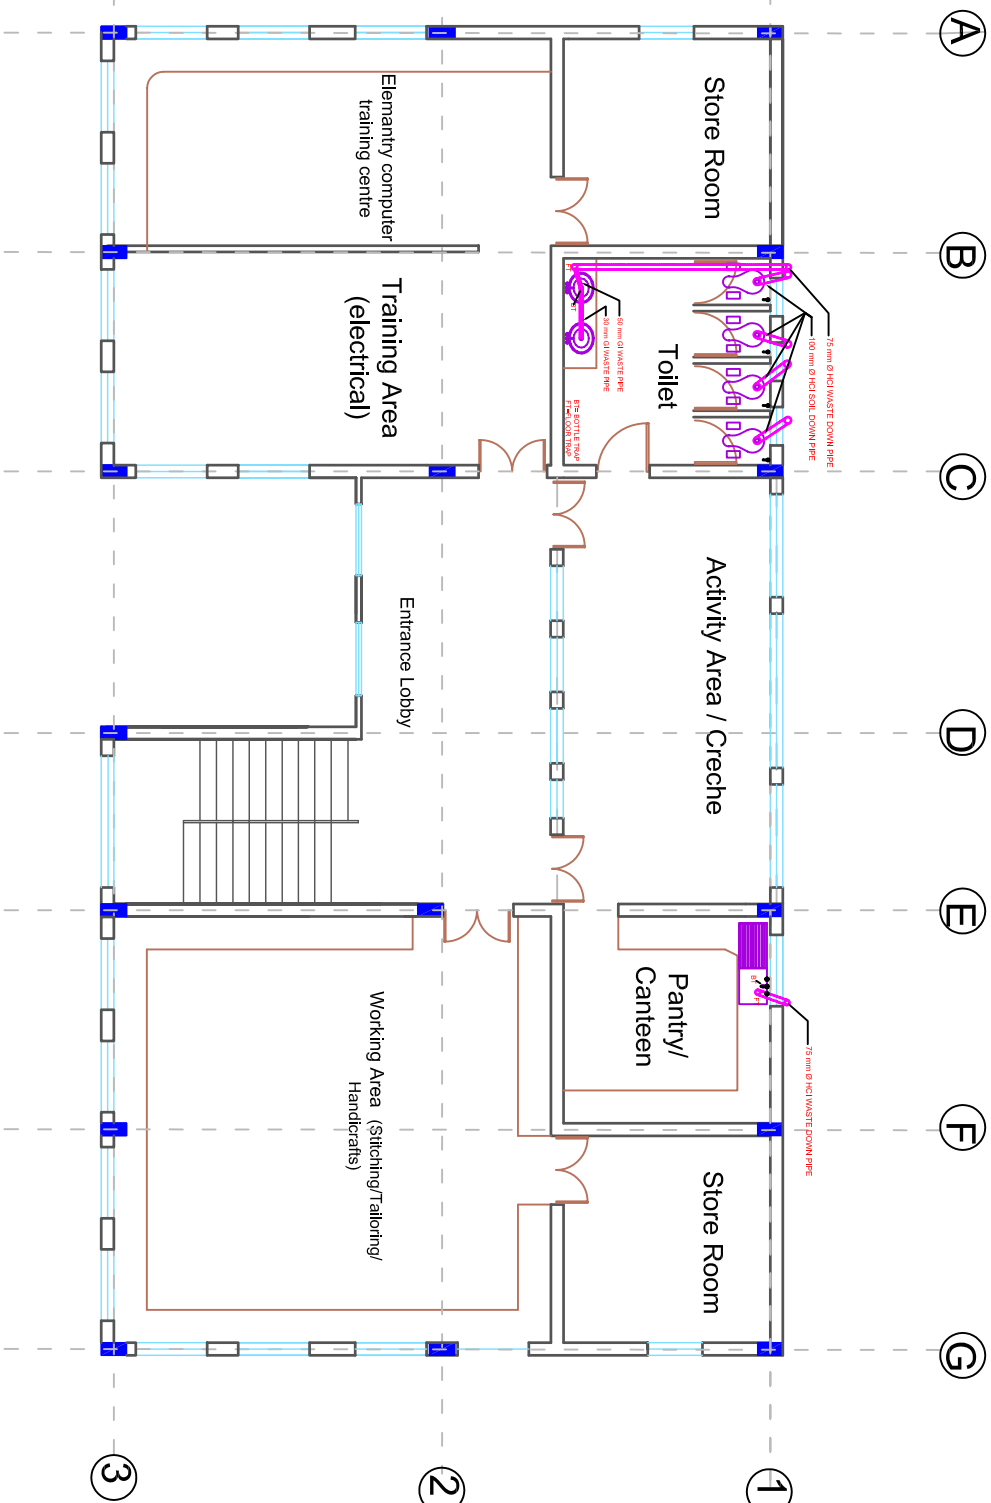

LEGEND FOR GROUND FLOOR

Symbol	Length in mm/No	Description
	4500	75 mm Ø HCI WASTE DOWN PIPE
	2400	100 mm Ø HCI WASTE DOWN PIPE
	7	Water Taps
FT	2	Floor Trap
BT	3	Boiler Trap

NOTE:
1. ONLY INTERNAL LENGTHS ARE MENTIONED IN THE
LEGEND

Project

BSUP, JHARKHAND

Sheet Title

LIVELIHOOD CENTRE (SMALL)- FIRST FLOOR PLAN

BUILT UP ON FIRST FLOOR : 280 Sq Mt

Drig. No.

LC1

Scale

APP




Date

03-02-2008


INFRASTRUCTURE PROFESSIONAL ENTERPRISE Pvt. Ltd.

C-2 GREEN PARK EXTENSION, DELHI

LEGEND FOR TERRACE FLOOR

Symbol	Length in mm/ft	Description
	4500	75 mm Ø HCI WASTE DOWN PIPE
	2400	100 mm Ø HCI WASTE DOWN PIPE
	7	Water Taps
FT	2	Floor Trap
BT	3	Boiler Trap

NOTE:
1. ONLY INTERNAL LENGTHS ARE MENTIONED IN THE
LEGEND

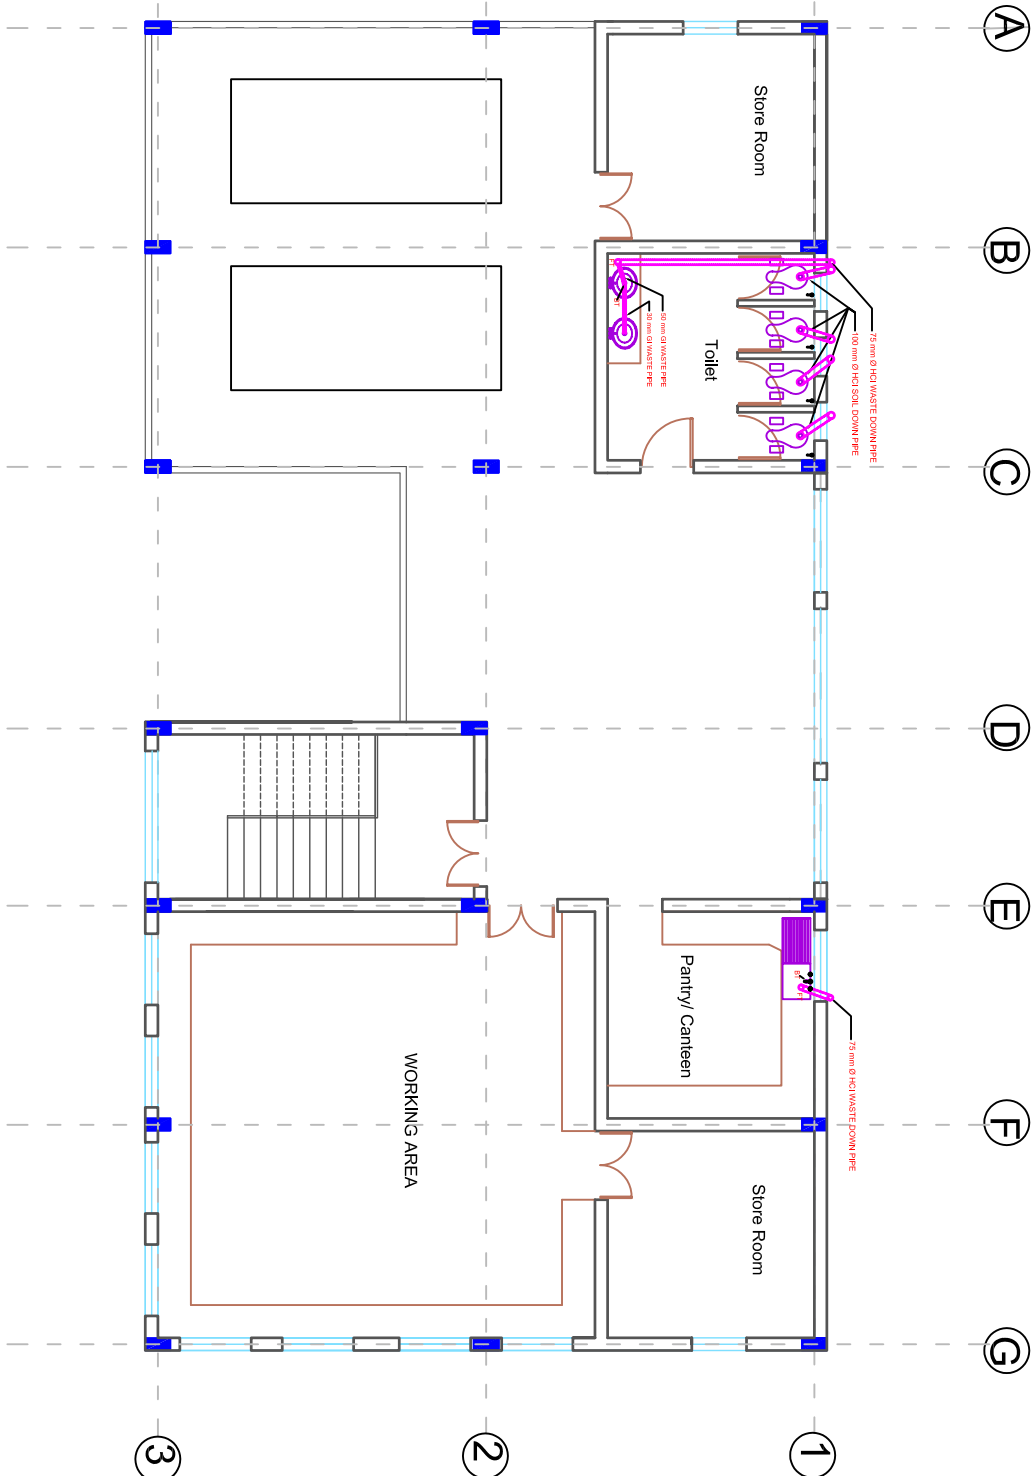

Project

BSUP, JHARKHAND

Sheet Title

LIVELIHOOD CENTRE (SMALL)- SECOND FLOOR PLAN

Dwg. No.

LC1

Scale

APP

Date 03-02-2008

INFRASTRUCTURE PROFESSIONAL ENTERPRISE Pvt. Ltd.





C- 2 GREEN PARK EXTENSION, DELHI


Project
LIVELIHOOD CENTER
Sheet Title
FOOTING PLAN AND DETAIL

Drg. No.
LC1
Scale
APP
Date
03-02-2008


INFRASTRUCTURE PROFESSIONAL ENTERPRISE Pvt. Ltd.
C-2 GREEN PARK EXTENSION, DELHI

D : 1200 X 2100 (2 shutter)
D1: 900X1800 (1 shutter)
W: 1300X1500 (2 shutter)
V: 700 X 500

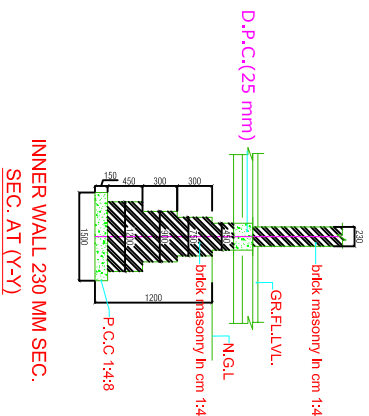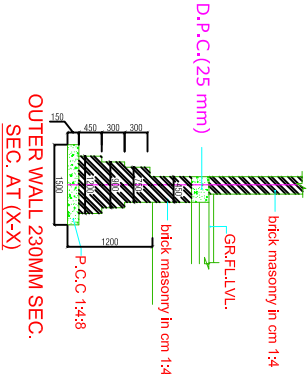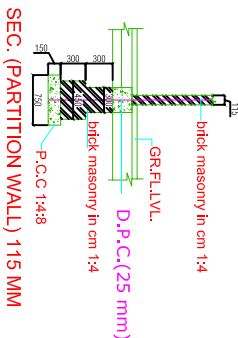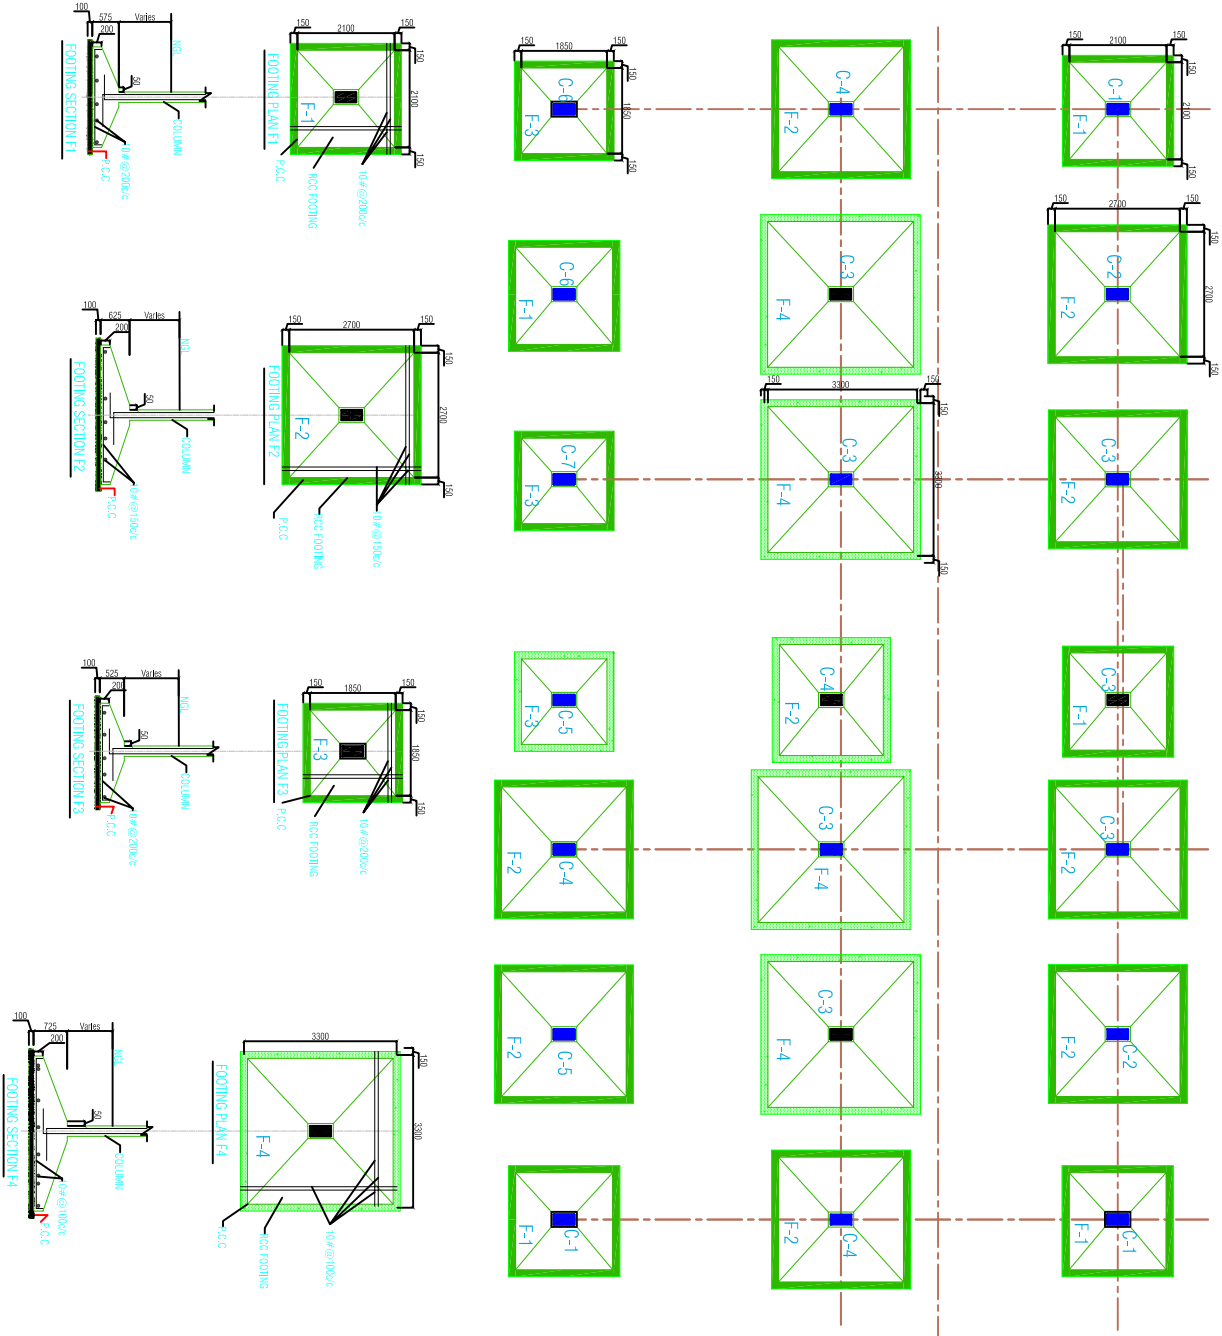

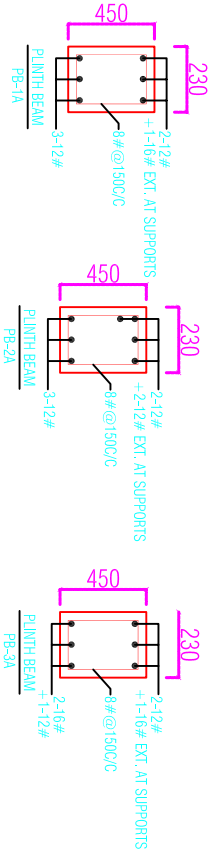

Project		Drg. No.	
LEVELHOOD CENTER		LC1	
Sheet Title		Scale APP	
PLINTH BEAM DETAIL		Date 03-02-2008	
D: 1200 X 2100 (2 shutter) Dt: 900x1800 (1 shutter) W: 1300X1500 (2 shutter) V: 700 X 500		INFRASTRUCTURE PROFESSIONAL ENTERPRISE Pvt. Ltd. C-2 GREEN PARK EXTENSION, DELHI	

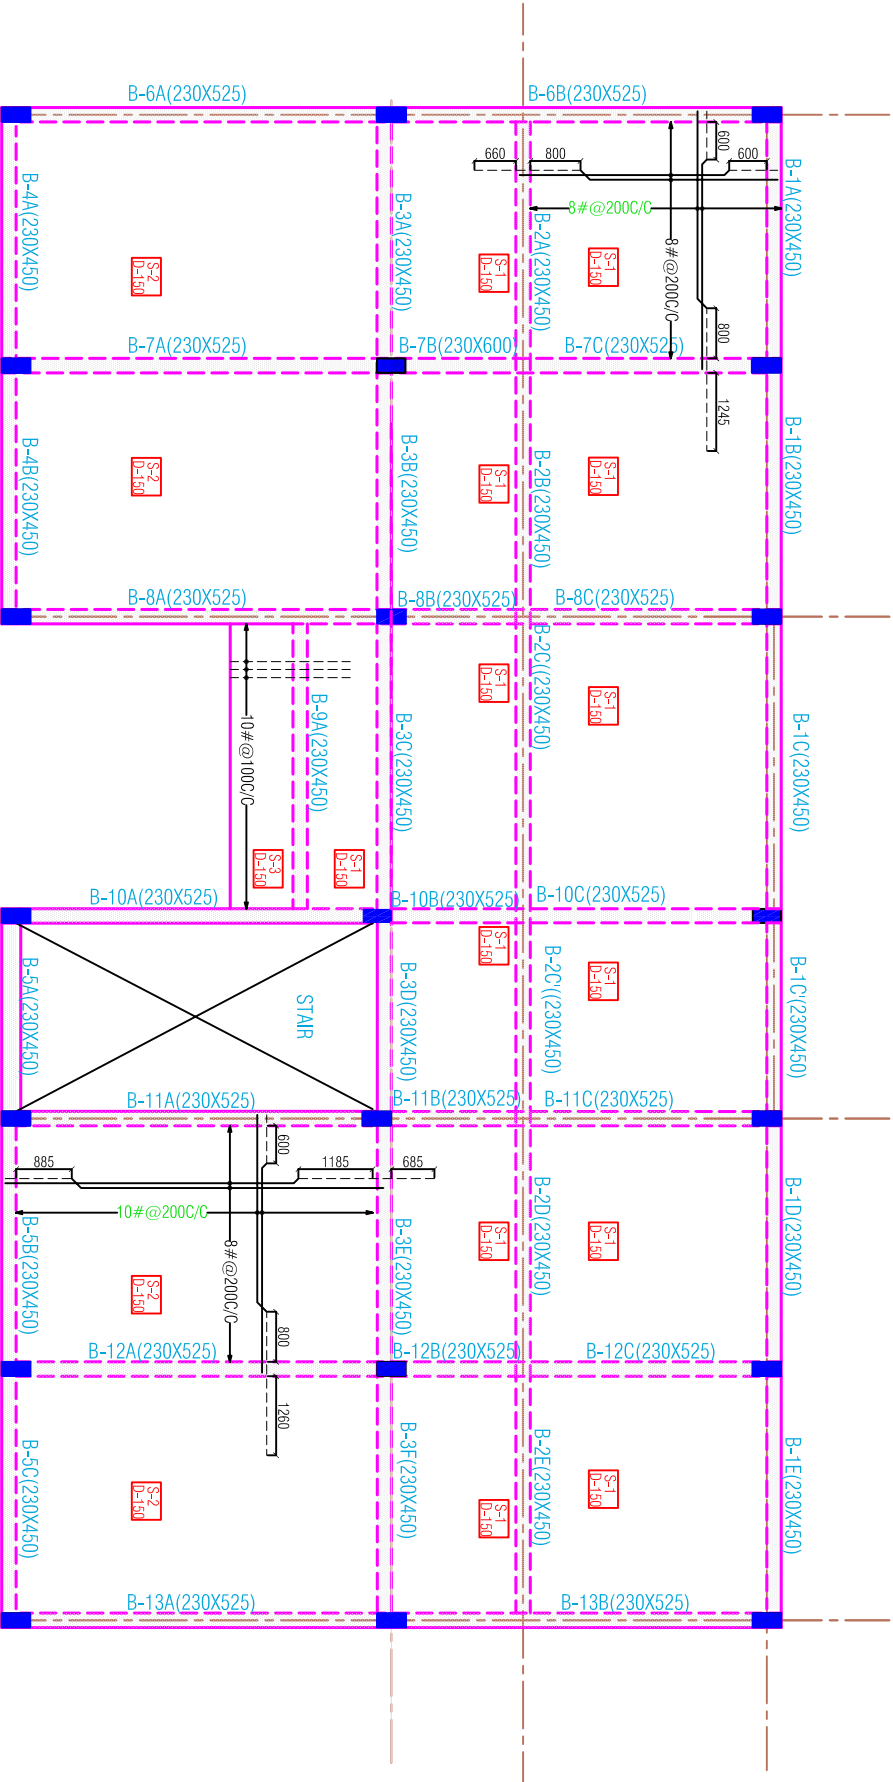

Project
LIVELIHOOD CENTER


Sheet Title
FIRST FLOOR FRAMING PLAN

D: 1200 X 2100 (2 shutter)
D1: 900X1800 (1 shutter)
W: 1300X1500 (2 shutter)
V: 700 X 500

Drg. No.
LC1

Scale APP
Date 03-02-2008

INFRASTRUCTURE PROFESIONAL ENTERPRISE Pvt. Ltd.
C- 2 GREEN PARK EXTENSION, DELHI

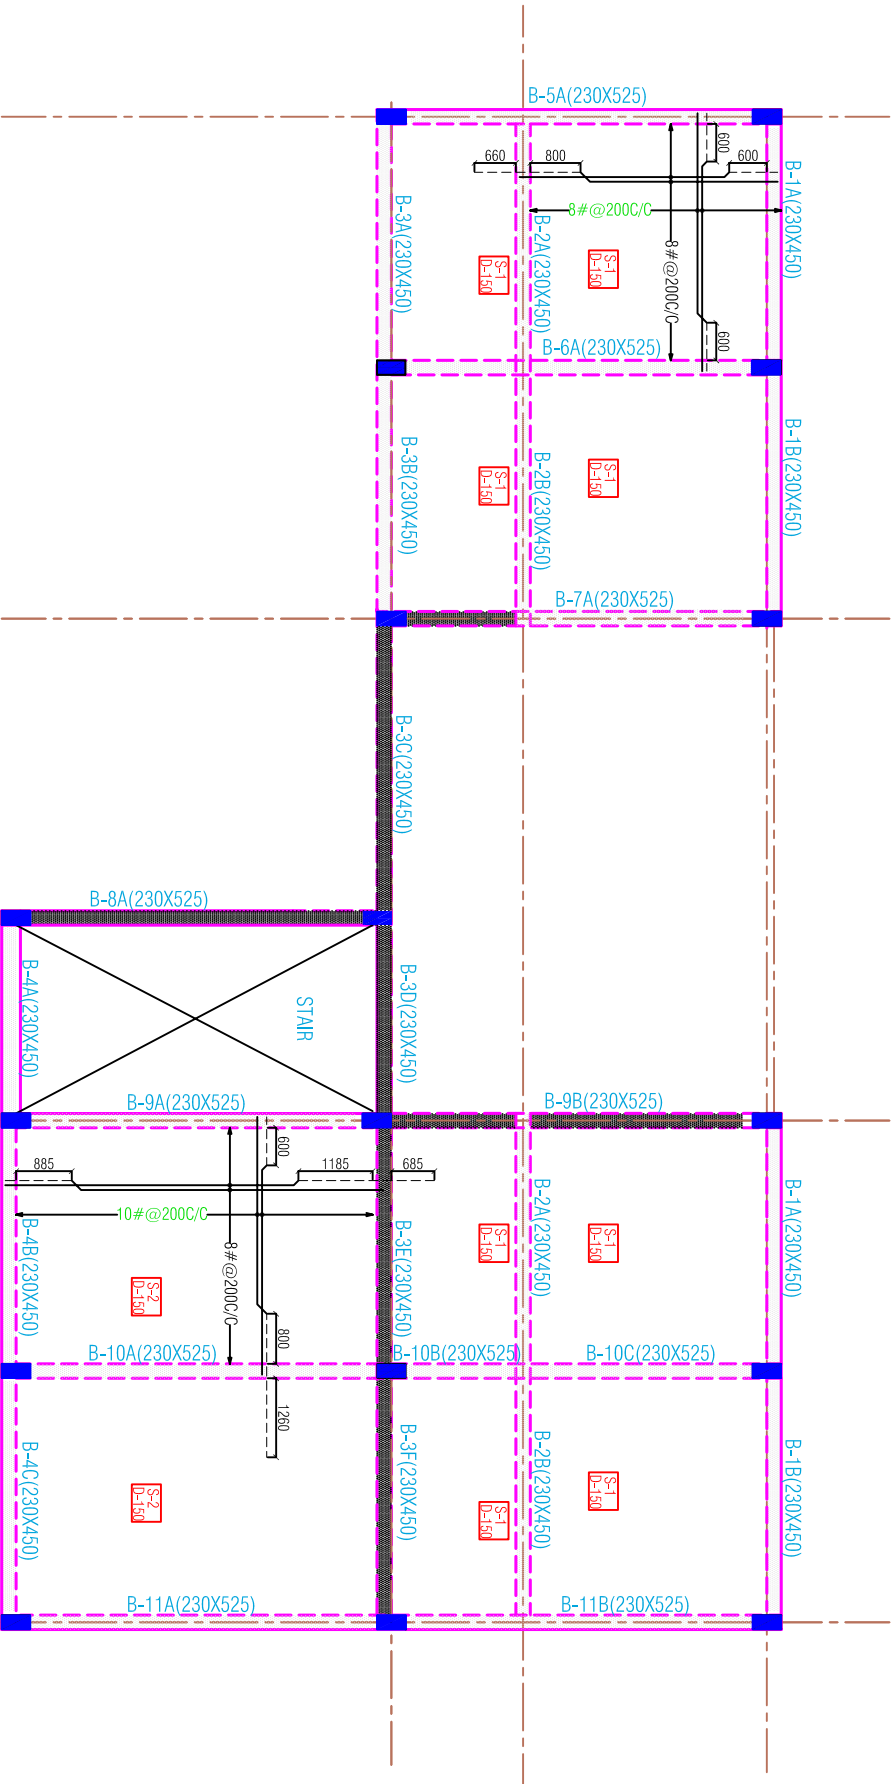

Project
LIVELIHOOD CENTER

Sheet Title
TERRACE FLOOR FRAMING PLAN

D: 1200 X 2100 (2 shutter)
D1: 900x1800 (1 shutter)
W: 1300X1500 (2 shutter)
V: 700 X 500


Drg. No.

LC1

Scale APP

Date 03-02-2008

INFRASTRUCTURE PROFESIONAL ENTERPRISE Pvt. Ltd.
C- 2 GREEN PARK EXTENSION, DELHI

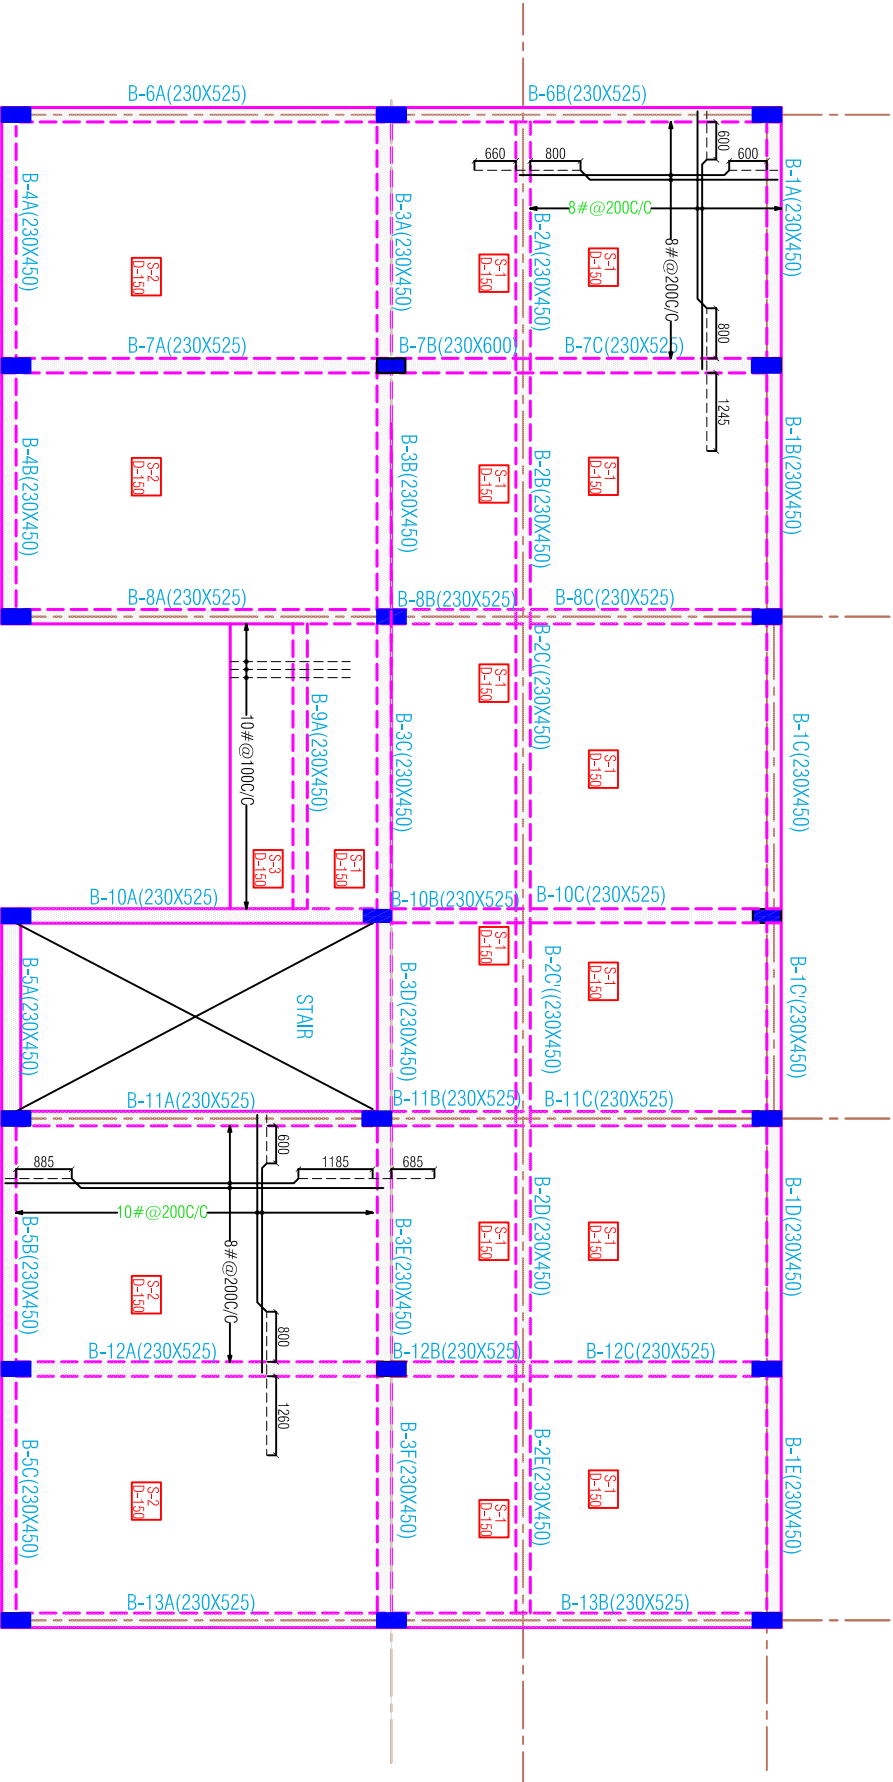

Project
LIVELIHOOD CENTER


Sheet Title
SECOND FLOOR FRAMING PLAN

D: 1200 X 2100 (2 shutter)
D1: 900X1800 (1 shutter)
W: 1300X1500 (2 shutter)
V: 700 X 500

Drg. No.
LC1

Scale APP
Date 03-02-2008

INFRASTRUCTURE PROFESIONAL ENTERPRISE Pvt. Ltd.
C- 2 GREEN PARK EXTENSION, DELHI

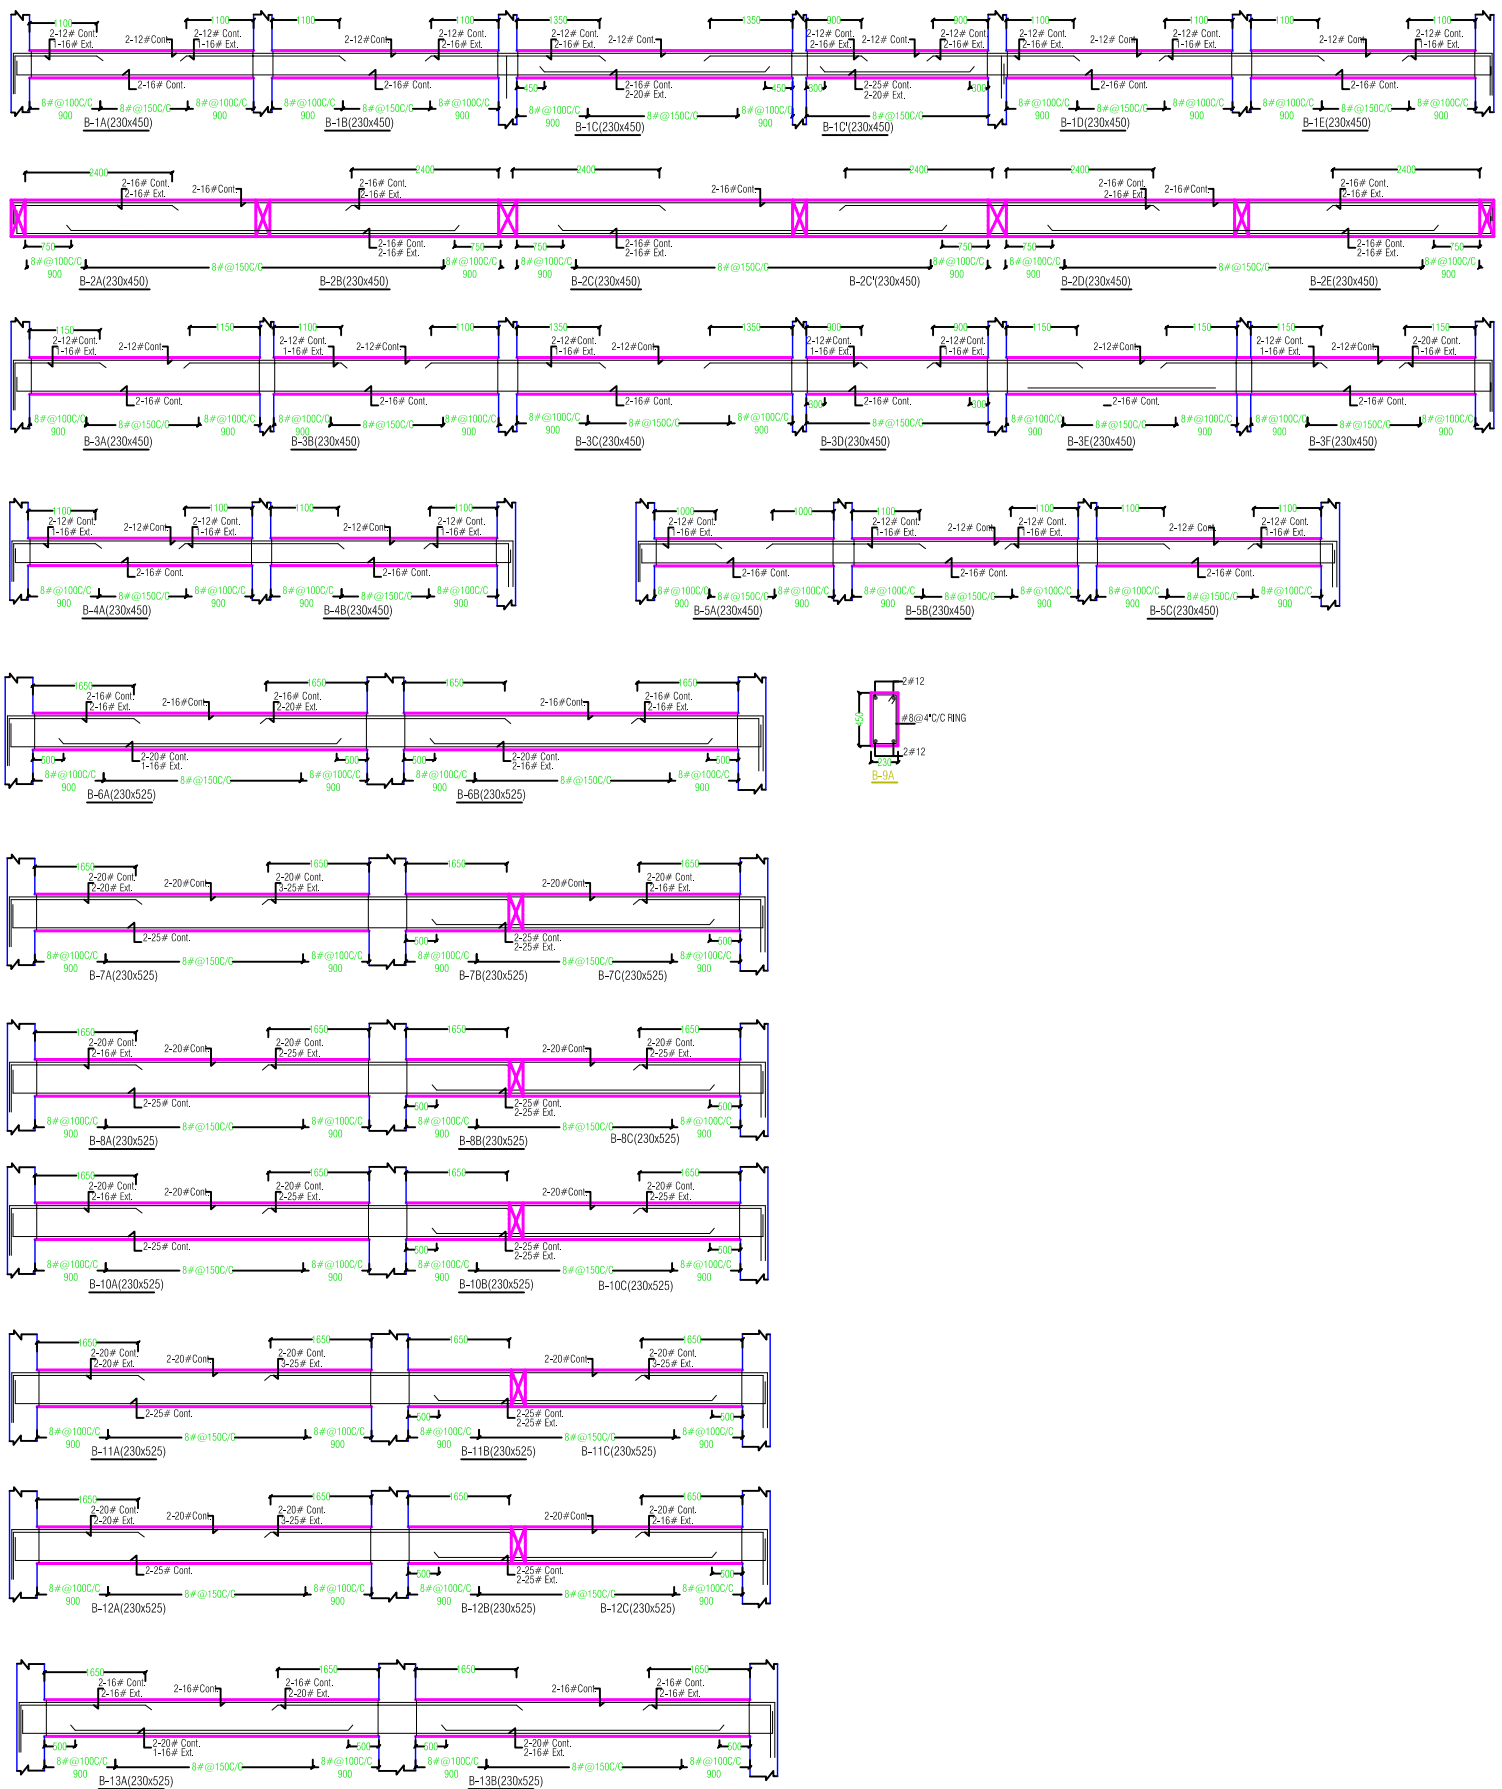


Project
LIVELIHOOD CENTER
 Sheet Title
SECOND FLOOR BEAM DETAIL

D: 1200 X 2100 (2 shutter)
 D1: 900x1800 (1 shutter)
 W: 1300X1500 (2 shutter)
 V: 700 X 500

Org. No.
LC1
 Scale APP
 Date 03-02-2008

INFRASTRUCTURE PROFESIONAL ENTERPRISE Pvt. Ltd.
 C- 2 GREEN PARK EXTENSION, DELHI

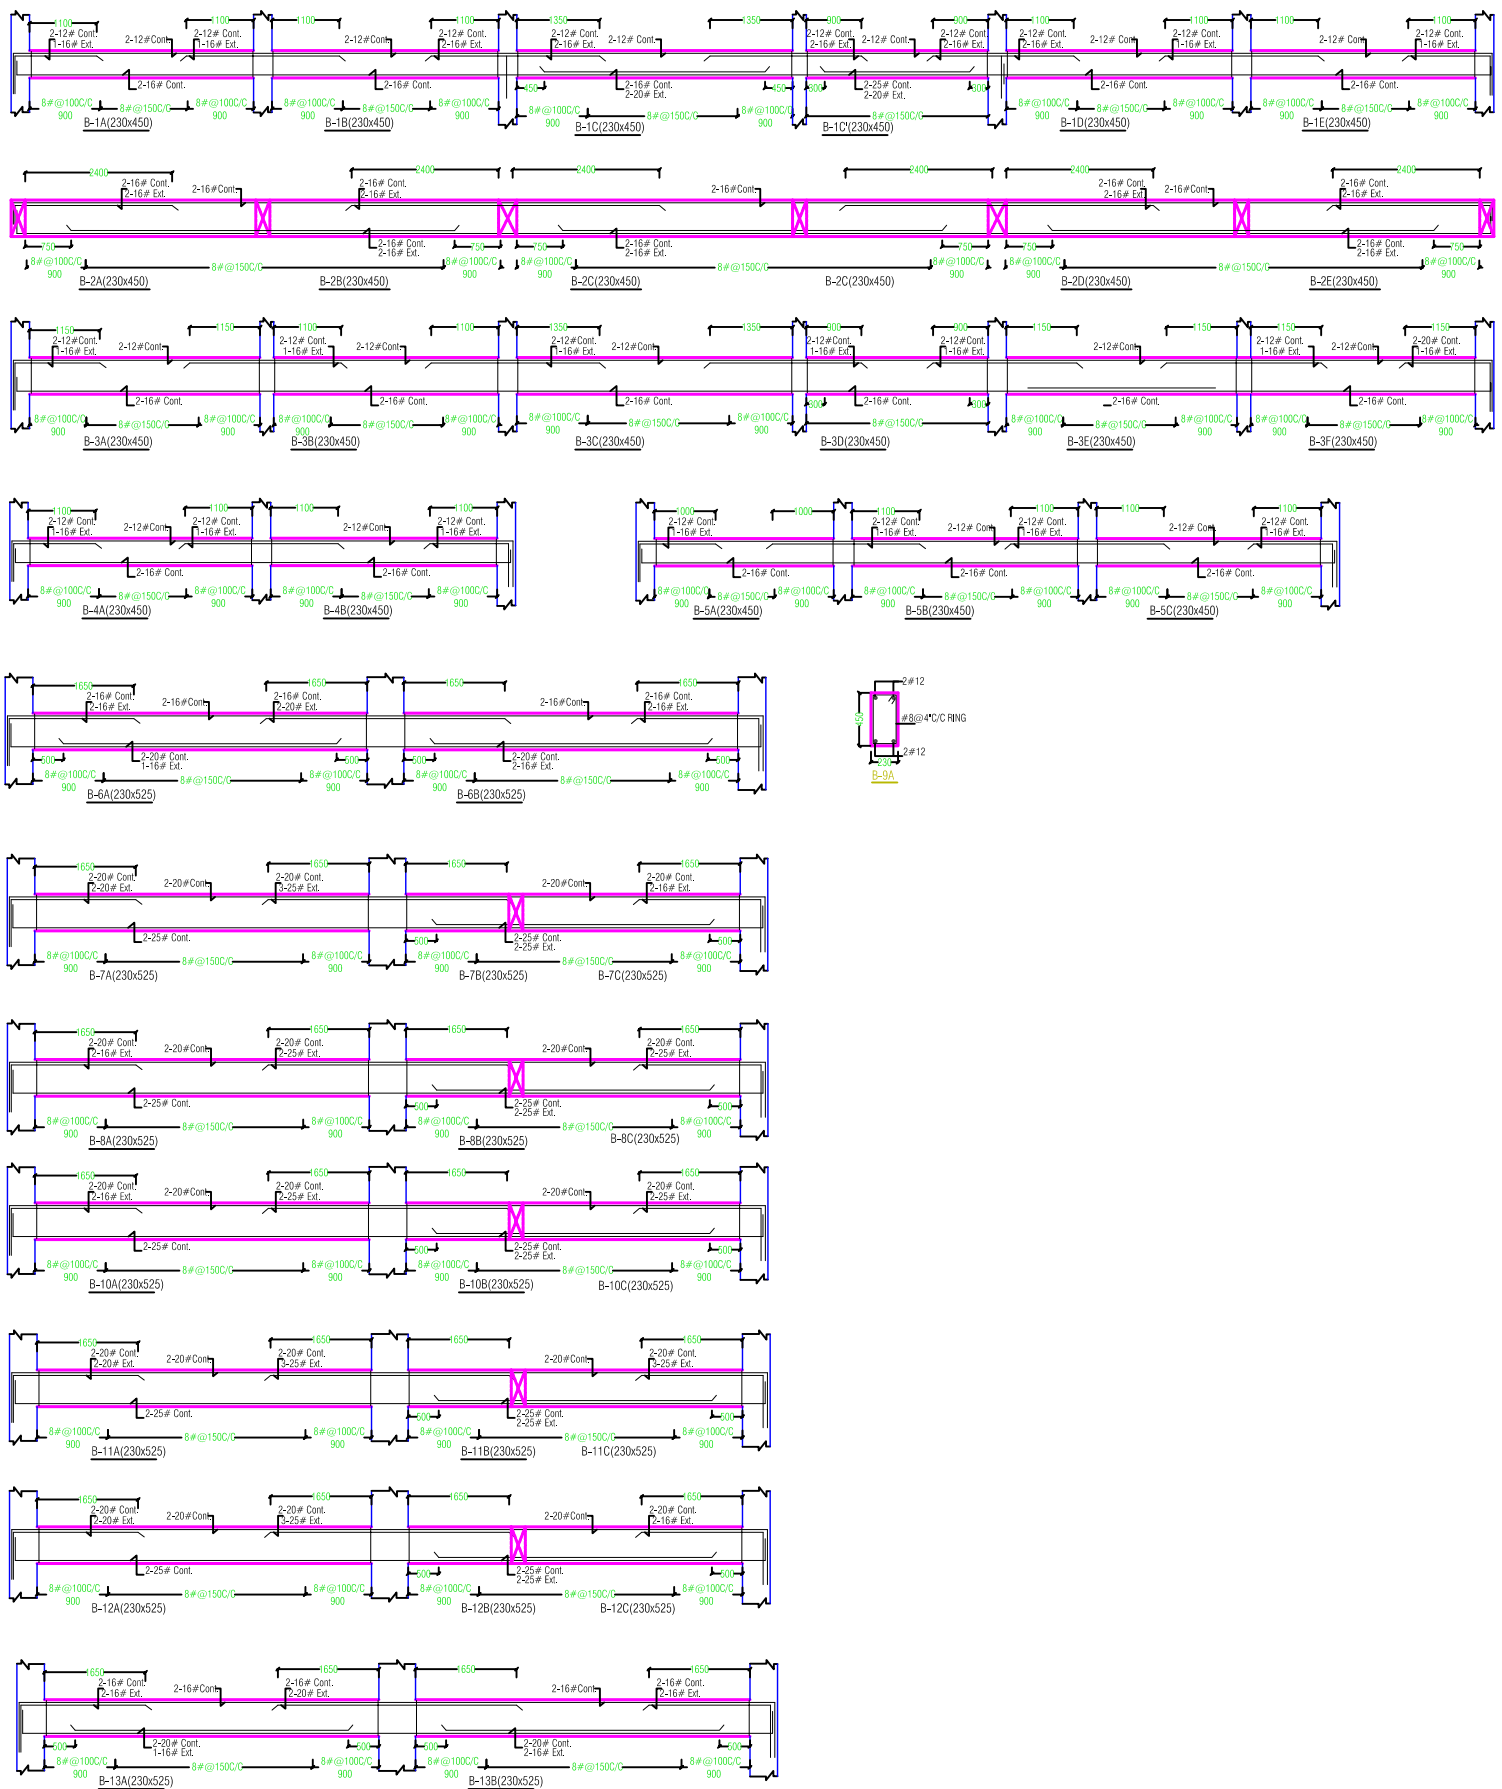

Project

Sheet Title

FIRST FLOOR BEAM DETAIL

D: 1200 X 2100 (2 shutter)
D1: 900X1800 (1 shutter)
W: 1300X1500 (2 shutter)
V: 700 X 500

Dr. No.

LC1


Scale APP

Date 03-02-2008


INFRASTRUCTURE PROFESIONAL ENTERPRISE Pvt. Ltd.

C- 2 GREEN PARK EXTENSION, DELHI

Beam refer roof level

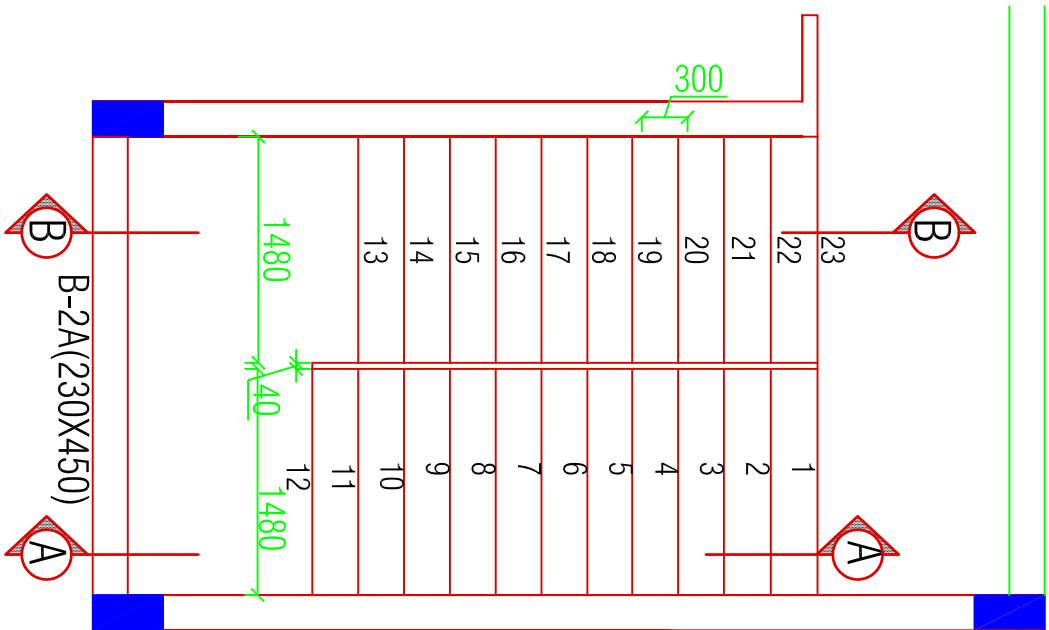


STAIR PLAN

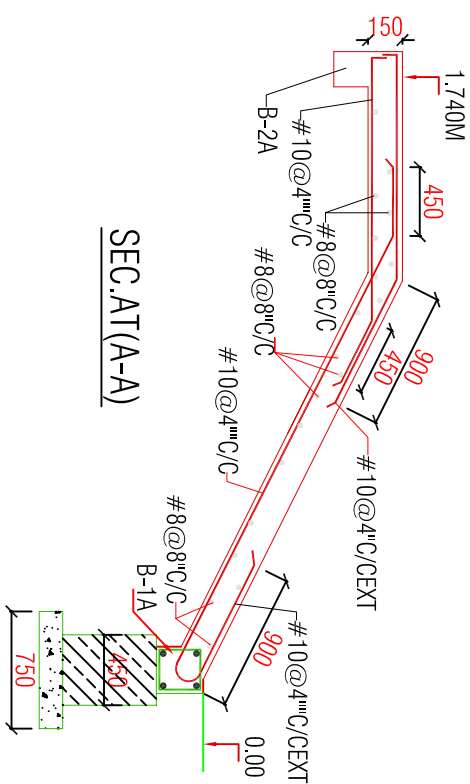


SEC.A1(A-A)

NUMBER OF RISER = 23 (174 MM)
NUMBER OF TREAD = 22 (300MM)
WIDTH OF LANDING = 1480MM

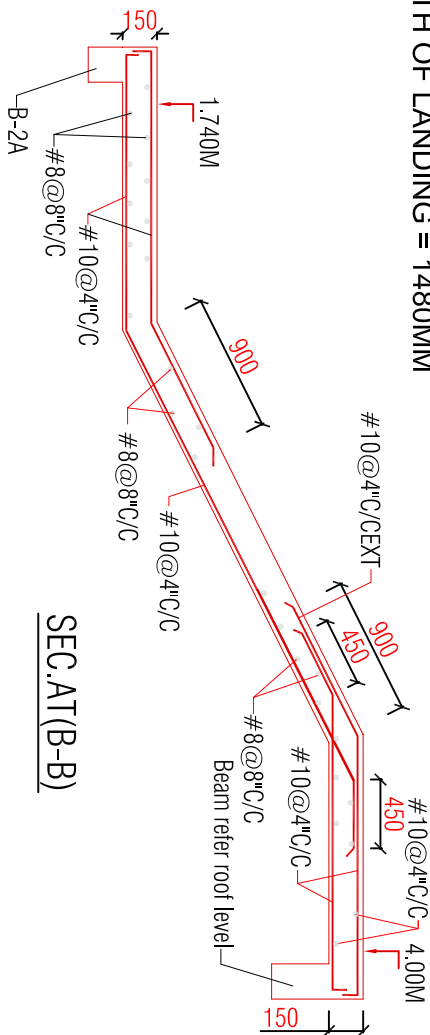

SEC.A1(B-B)

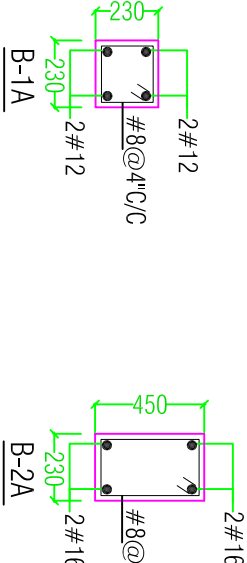

Project

JnNURM

Sheet Title

STAIR DETAIL: LIVELIHOOD CENTRE

D: 1200 X 2100 (2 shutter)
D1: 900X1800 (1 shutter)
W: 1300X1500 (2 shutter)
V: 700 X 500

Drg. No.

LC1

Scale APP

Date

03-02-2008

INFRASTRUCTURE PROFESSIONAL ENTERPRISE Pvt. Ltd.
C- 2 GREEN PARK EXTENSION, DELHI